



SE D LATERAL DRAINAGE

BENTONVILLE, ARKANSAS
30% DESIGN SUBMITTAL

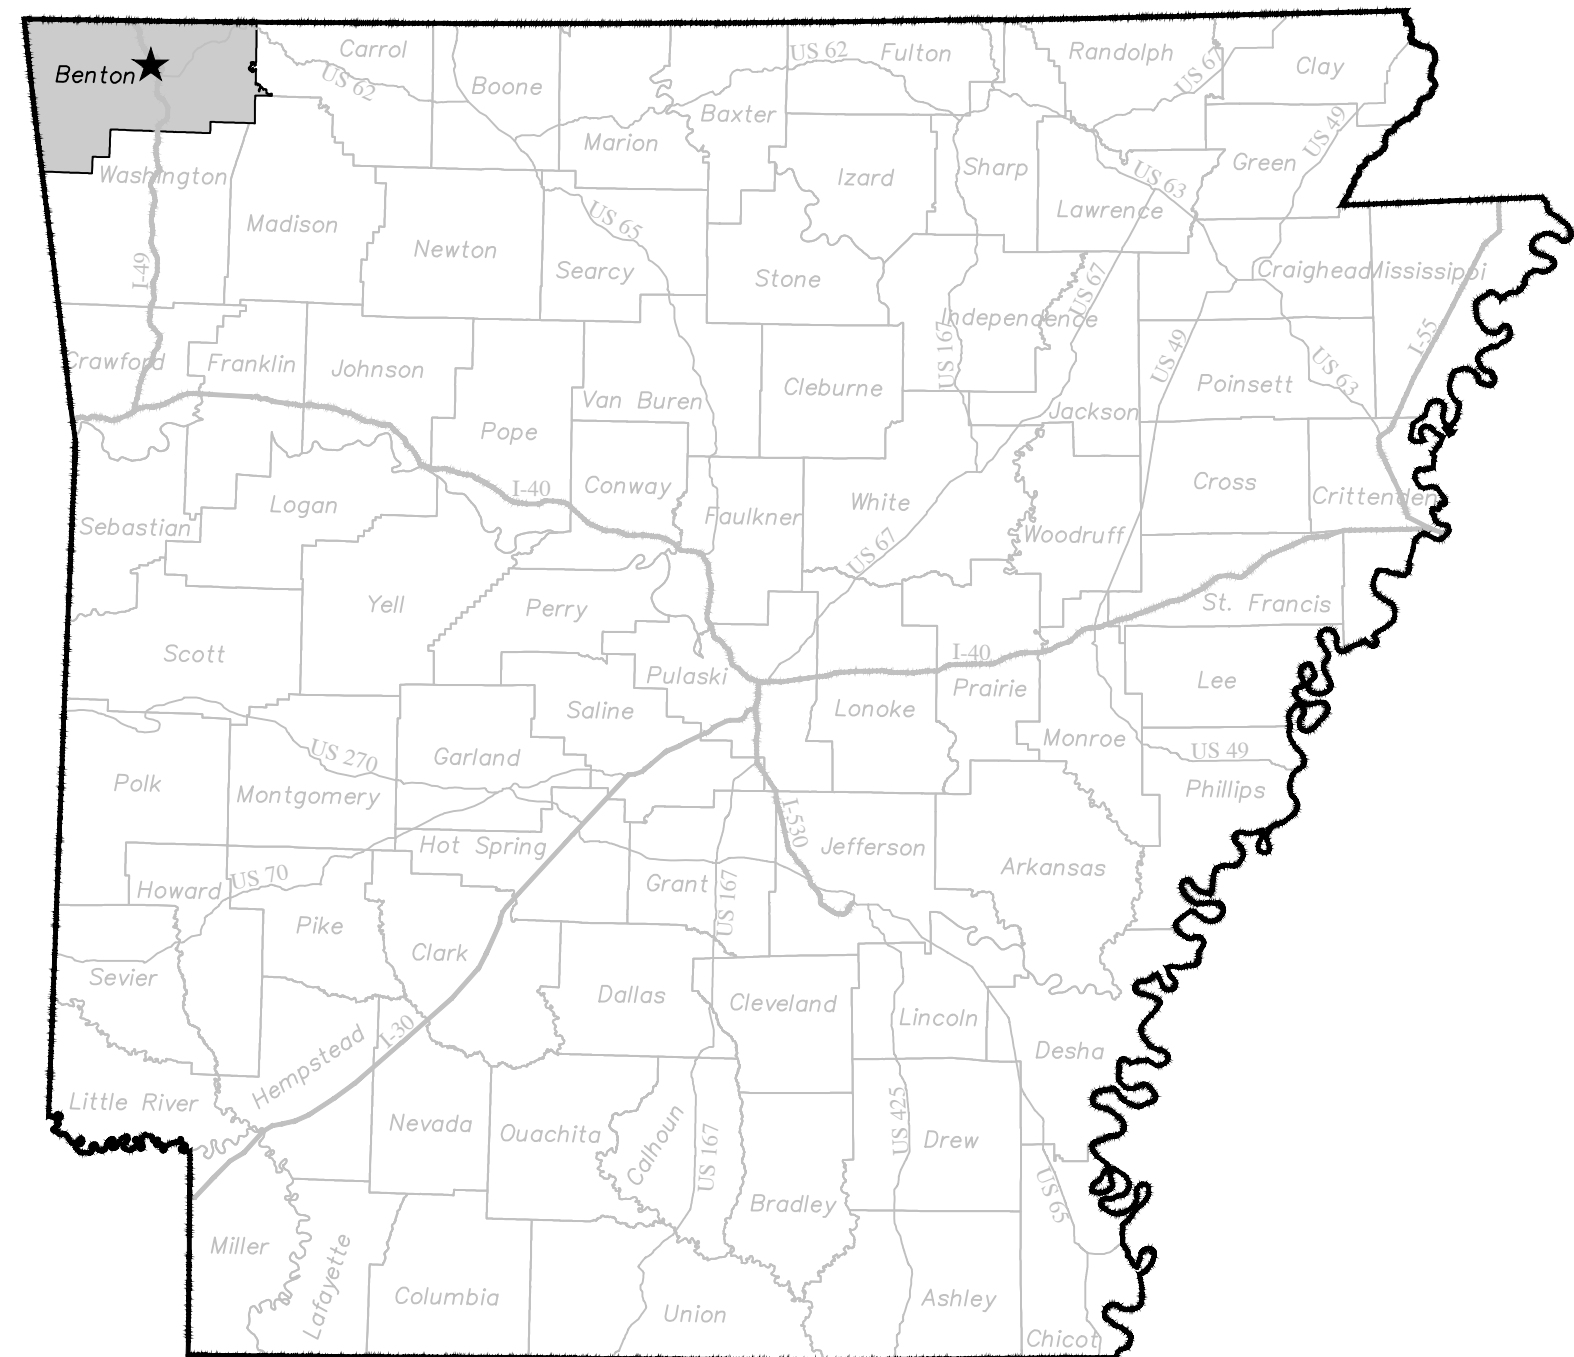

LOCATION MAP

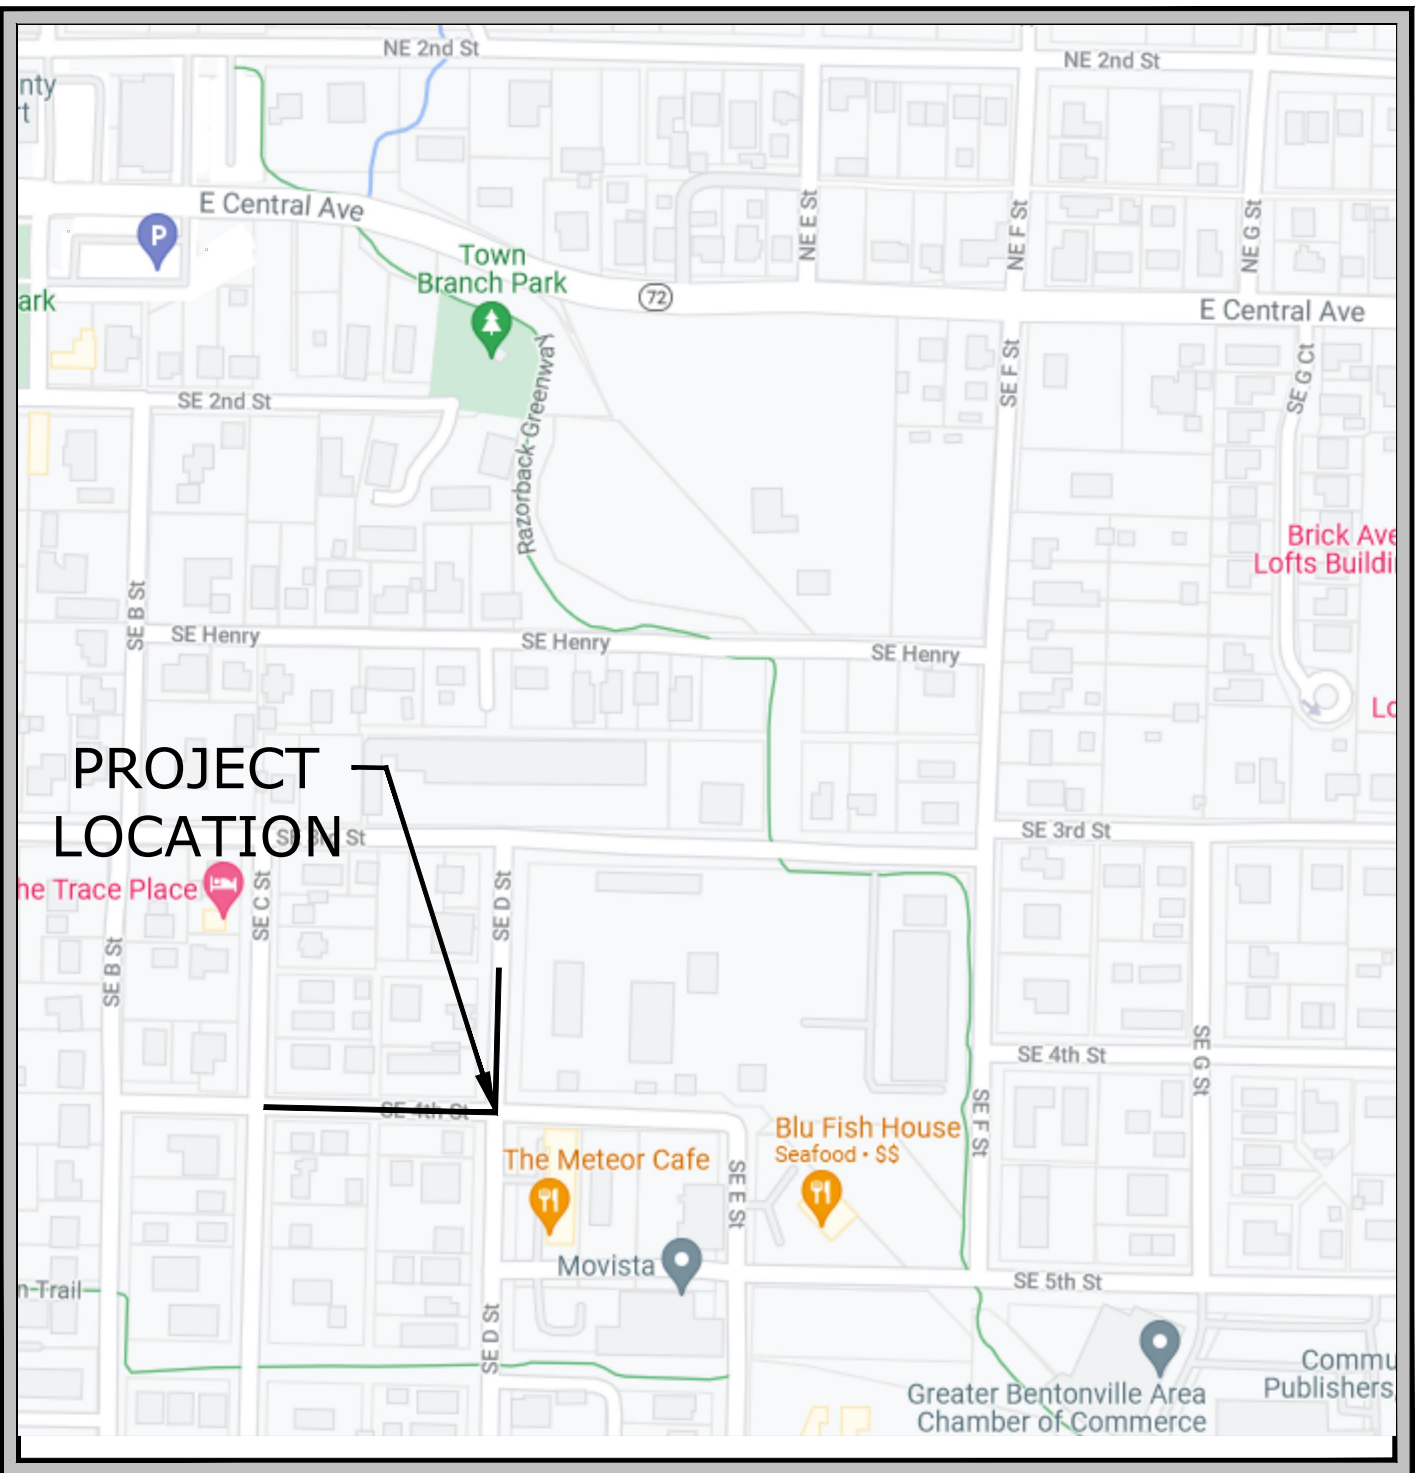

VICINITY MAP



PROJECT & UTILITY CONTACTS

BLACK HILLS ENERGY
CONTACT: JOSH KNIGHT
PHONE: (479) 721-4543
EMAIL: joshua.knight@blackhillscorp

COX COMMUNICATIONS
CONTACT: KIP SMITH
PHONE: (479) 717-3796
EMAIL: kip.smith@cox.com

CITY OF BENTONVILLE WATER & SEWER
CONTACT: PRESTON NEWBILL
PHONE: (479) 271-3140

CITY OF BENTONVILLE ELECTRIC
CONTACT: CHARLIE BARNES
PHONE: (479) 271-3159

AT&T
CONTACT: SCOTT SEAMAN
PHONE: (479) 442-1967


CONTACT: LAYNE RHODES
PHONE: (479) 442-1977

CITY OF BENTONVILLE WASTEWATER
CONTACT: NANCY BUSEN
PHONE: (479) 271-3160

CITY OF BENTONVILLE FIRE DEPARTMENT
CONTACT: BRENT BOYDSTON
PHONE: (479) 271-5927

DEPARTMENT OF HEALTH
PHONE: (501) 661-2623

FEBRUARY 2022
MCE PROJECT NUMBER 21-2148

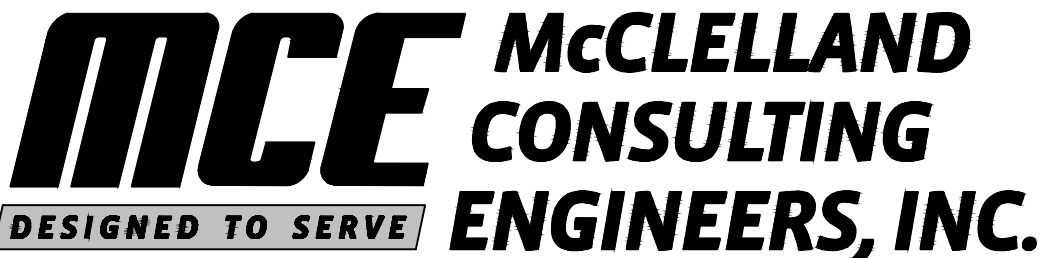

<http://www.mce.us.com>

1580 E STEARNS ST
FAYETTEVILLE, ARKANSAS 72703
(479) 443-2377



Know what's below.
Call before you dig.



PRELIMINARY
NOT FOR
CONSTRUCTION

ORIGINAL SIGNATURE ON FILE

LITTLE ROCK, AR • FAYETTEVILLE, AR • FORT SMITH, AR • TULSA, OK

SE D LATERAL, DRAINAGE BENTONVILLE, ARKANSAS MCE #21-2148 FEBRUARY 2022

Y:\2021\21-2148 - SE D Lateral, Drainage\Design Drawings\Civil\21-2148-DESIGN.dwg, PRINTED ON: February 4, 2022 @ 12:11 PM

INDEX TO DRAWINGS

- 1 COVER
- 2 INDEX OF SHEETS & KEY MAP
- TSU-1 TOPOGRAPHIC AND UTILITY SURVEY STA. 100+00 TO STA. 106+00
- TS-1 TYPICAL SECTION
- PP-1 PLAN AND PROFILE STA. 100+00 TO STA. 102+00
- PP-2 PLAN AND PROFILE STA. 102+00 TO STA. 106+00
- PP-3 PLAN AND PROFILE STA. 200+00 TO STA. 201+00
- PP-4 PLAN AND PROFILE STA. 300+00 TO STA. 301+50



DESIGNED BY:
ACP

DATE:
FEB 2022

SCALE:
1" = 30'

DRAWN BY :
ACP

REVISION:

JOB NUMBER:
21-2148

2

811
Know what's below.
Call before you dig.

THE CITY OF
BENTONVILLE

SE D LATERAL
DRAINAGE
BENTONVILLE, ARKANSAS


PRELIMINARY
NOT FOR
CONSTRUCTION

ORIGINAL SIGNATURE ON FILE

MCE McCLELLAND
CONSULTING
ENGINEERS, INC.
1580 E STEARNS ST
FAYETTEVILLE, ARKANSAS 72703
(479) 443-2377
HTTP://WWW.MCE.US.COM

©2022


Y:\2021\21-2148 - SE D Lateral, Drainage\Design Drawings\Civil\21-2148-TOPO.dwg, PRINTED ON: January 31, 2022 @ 3:57 PM

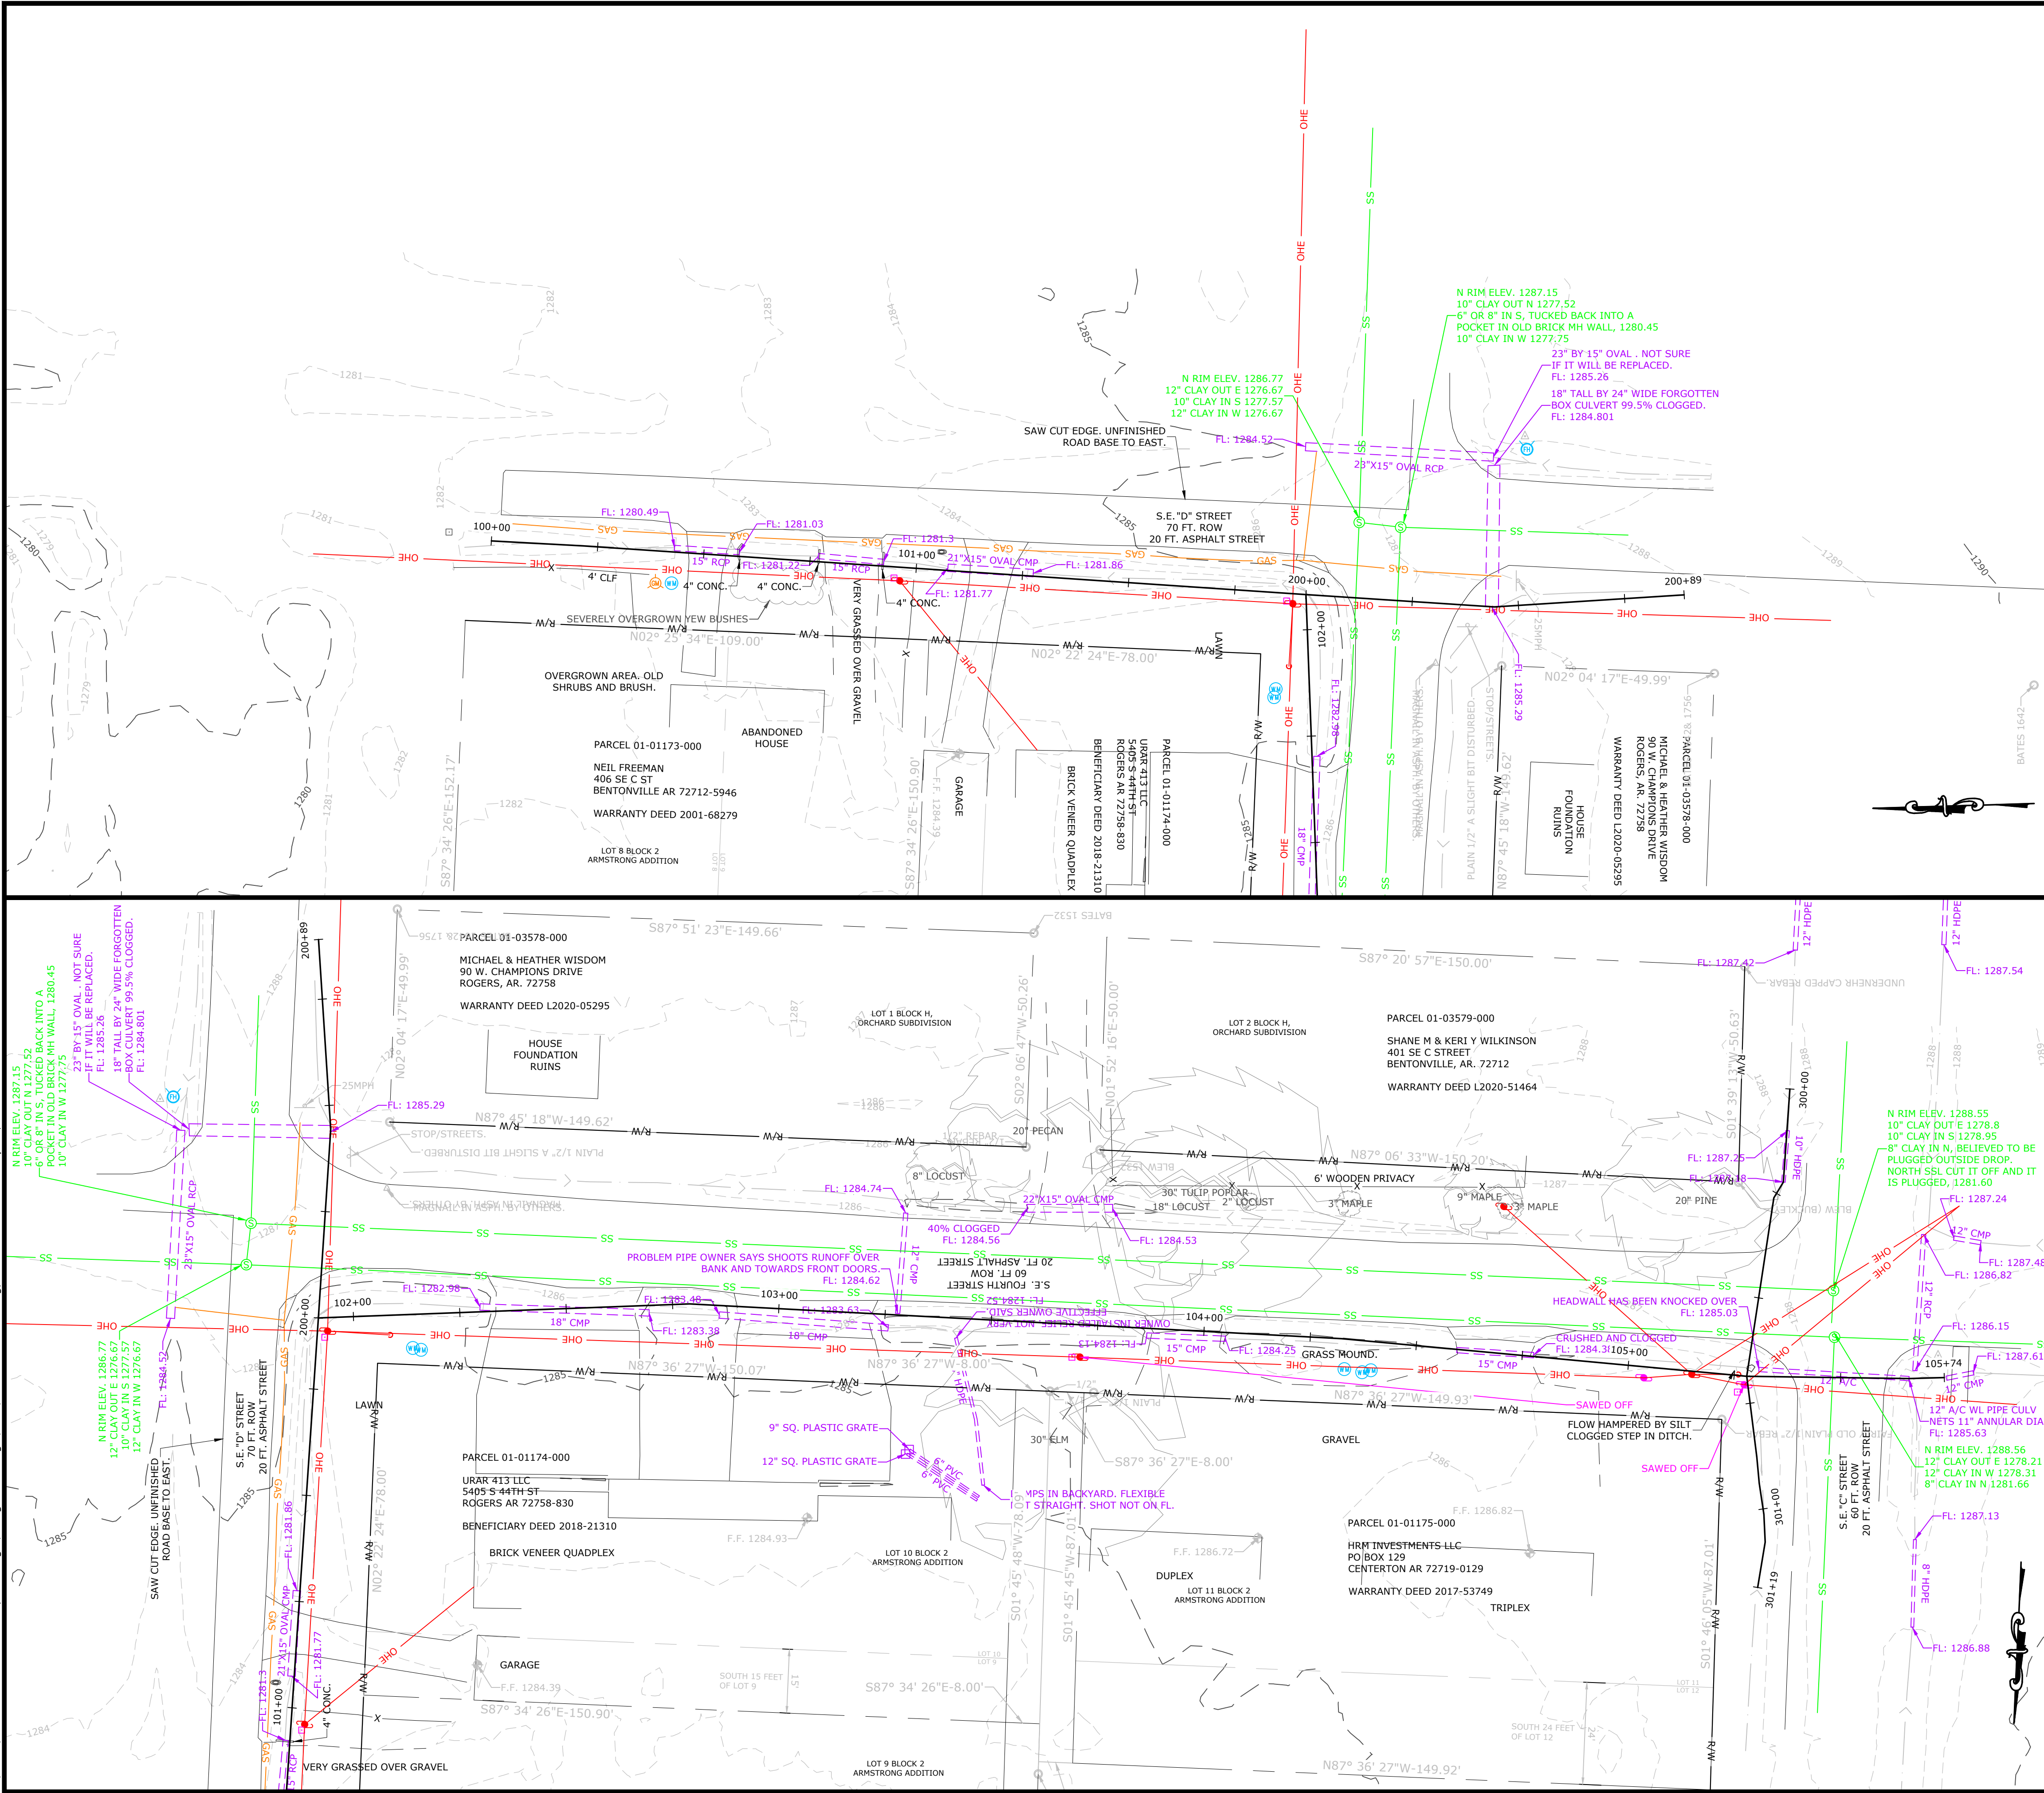

PROPOSED LEGEND

- | | | | |
|------|------------------------|-----|---------------------------|
| SS | SANITARY SEWER LINE | W | WATER FAUCET |
| WA | WATER LINE | SS | SANITARY SEWER MH |
| GAS | GAS LINE | CO | CLEAN-OUT |
| UGT | UNDERGROUND TELEPHONE | DMH | DRAINAGE MH |
| UGE | UNDERGROUND ELECTRIC | PP | POWER POLE |
| UGTV | UNDERGROUND TELEVISION | GWA | GUY WIRE w/ ANCHOR |
| UFO | UNDERGROUND FIBER | GM | GAS METER |
| OHE | OVERHEAD ELECTRIC | GR | GAS RISER |
| SDP | STORM DRAINAGE PIPE | SLP | STREET LIGHT POLE |
| X | FENCE | TP | TELEPHONE PEDESTAL |
| RC | ROAD CENTERLINE | CVP | CABLE TV PEDESTAL |
| DF | DITCH FLOWLINE | S | SIGN (AS NOTED) |
| EL | EASEMENT LINE | P | POST (AS NOTED) |
| GL | GRAVEL LINE | B | BENCHMARK |
| FH | FIRE HYDRANT | FIP | FOUND IRON PIN (AS NOTED) |
| WM | WATER METER | CP | CONTROL POINT |
| WV | WATER VALVE | RS | RR SPIKE |
| | | T | TREE |

- | | |
|-------|-----------------------------|
| 23+00 | PROPOSED DRAINAGE ALIGNMENT |
| R/W | EXISTING RIGHT-OF-WAY |
| --- | PROPERTY LINE |

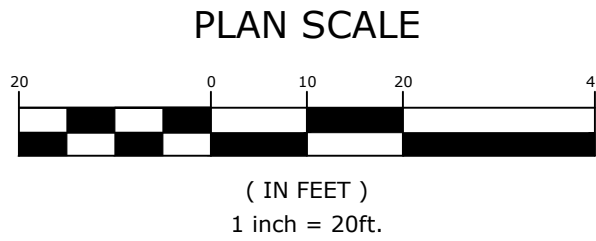

MCE McCLELLAND CONSULTING ENGINEERS, INC.
1580 E STEARNS ST
FAYETTEVILLE, ARKANSAS 72703
(479) 443-2377
HTTP://WWW.MCE.US.COM

PRELIMINARY
NOT FOR
CONSTRUCTION

ORIGINAL SIGNATURE ON FILE

SE D LATERAL
DRAINAGE
BENTONVILLE, ARKANSAS





REVISIONS		DESCRIPTION
REV	DATE	

TOPOGRAPHIC
AND UTILITY
SURVEY STA.
100+00 TO
STA. 106+00

DESIGNED BY: ACP	DRAWN BY: ACP
DATE: FEB 2022	REVISION:
SCALE: 1" = 20'	JOB NUMBER: 21-2148

TSU-1

Y:\2021\21-2148 - SE D Lateral, Drainage\Design Drawings\Civil\21-2148-DESIGN.dwg, PRINTED ON: February 4, 2022 @ 12:12 PM

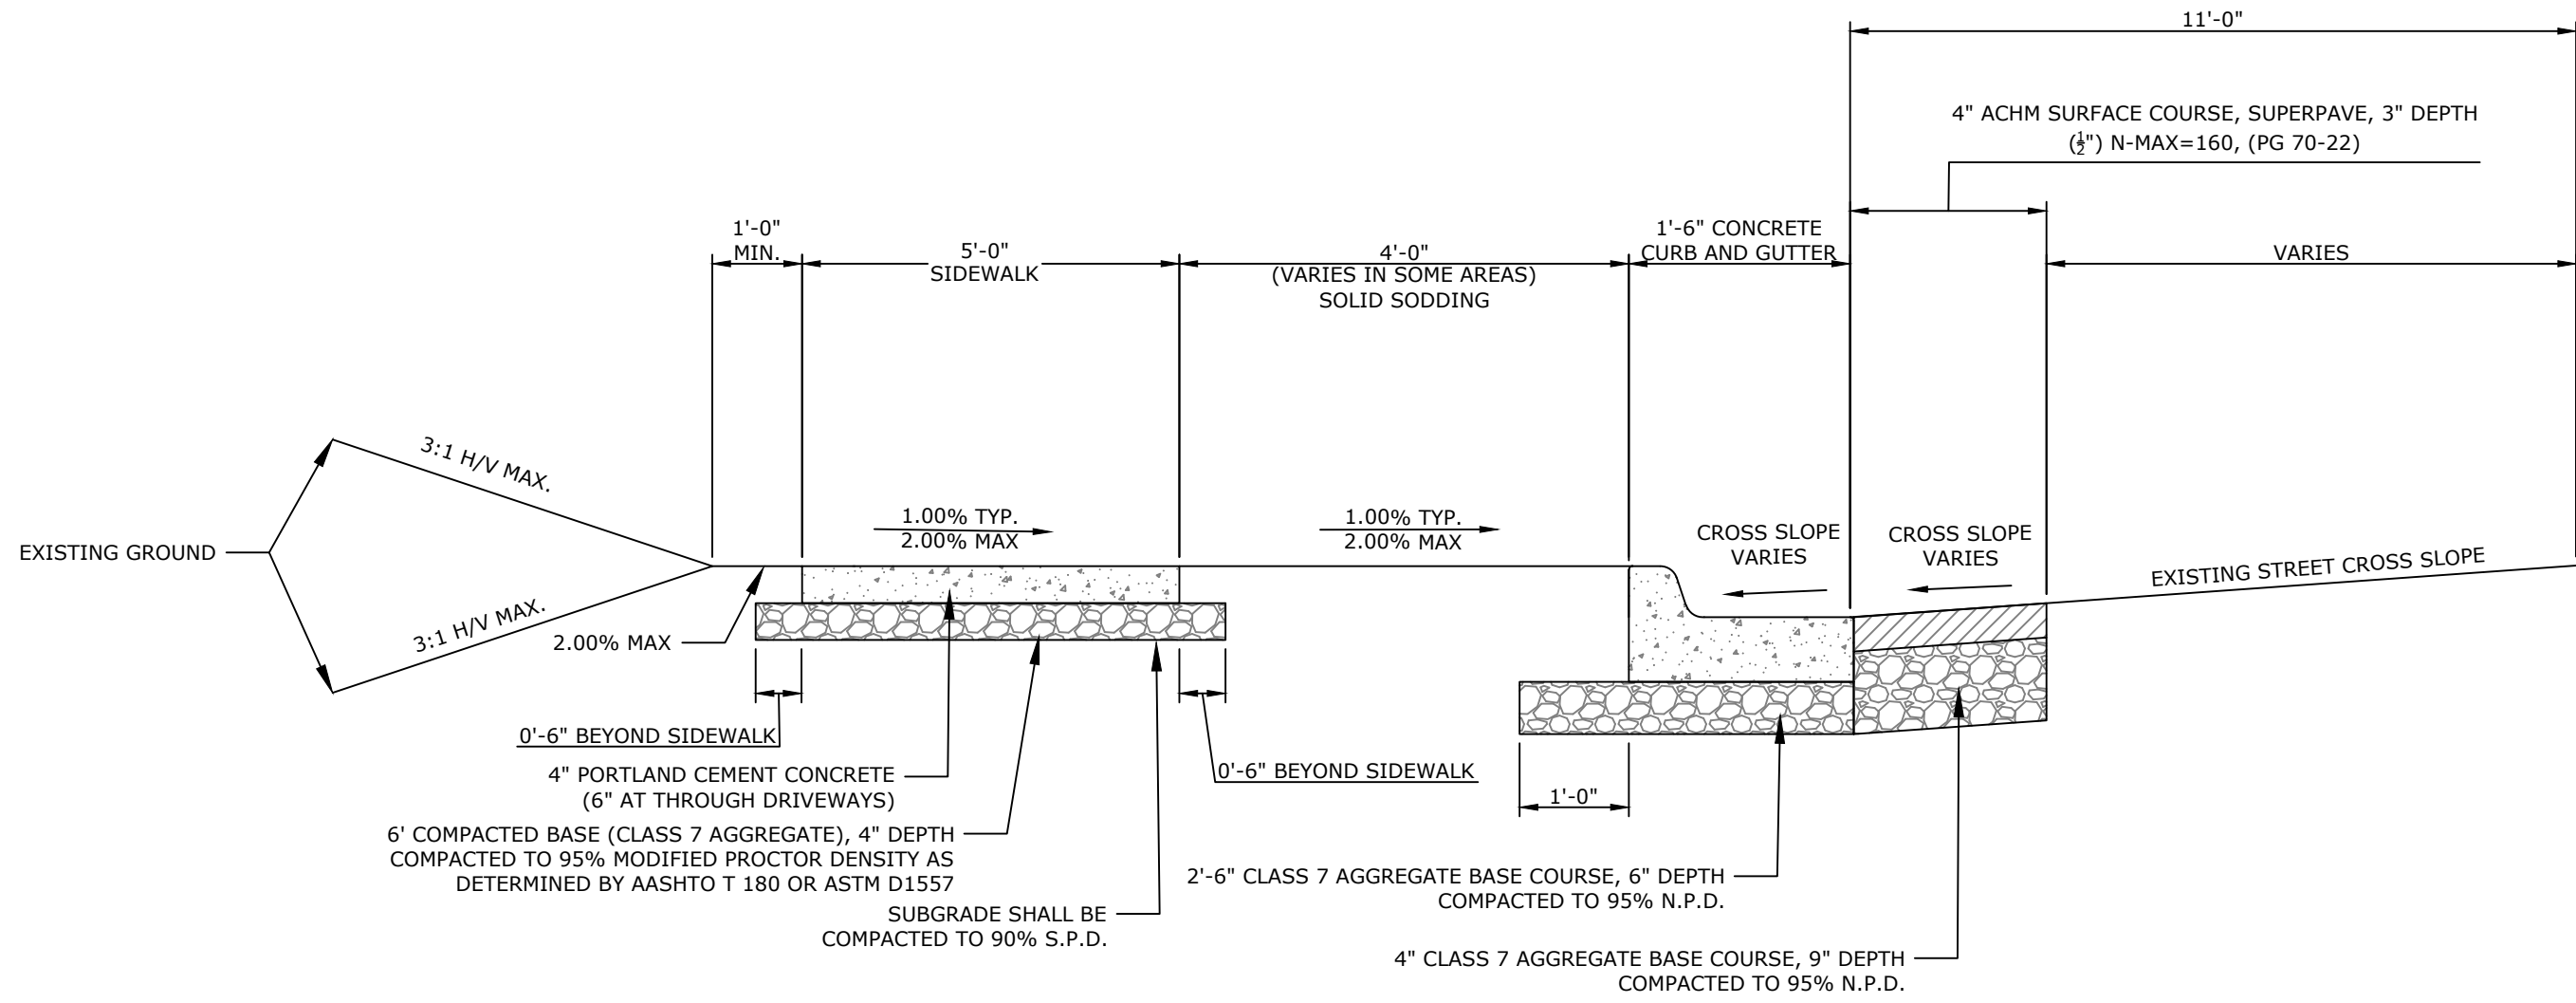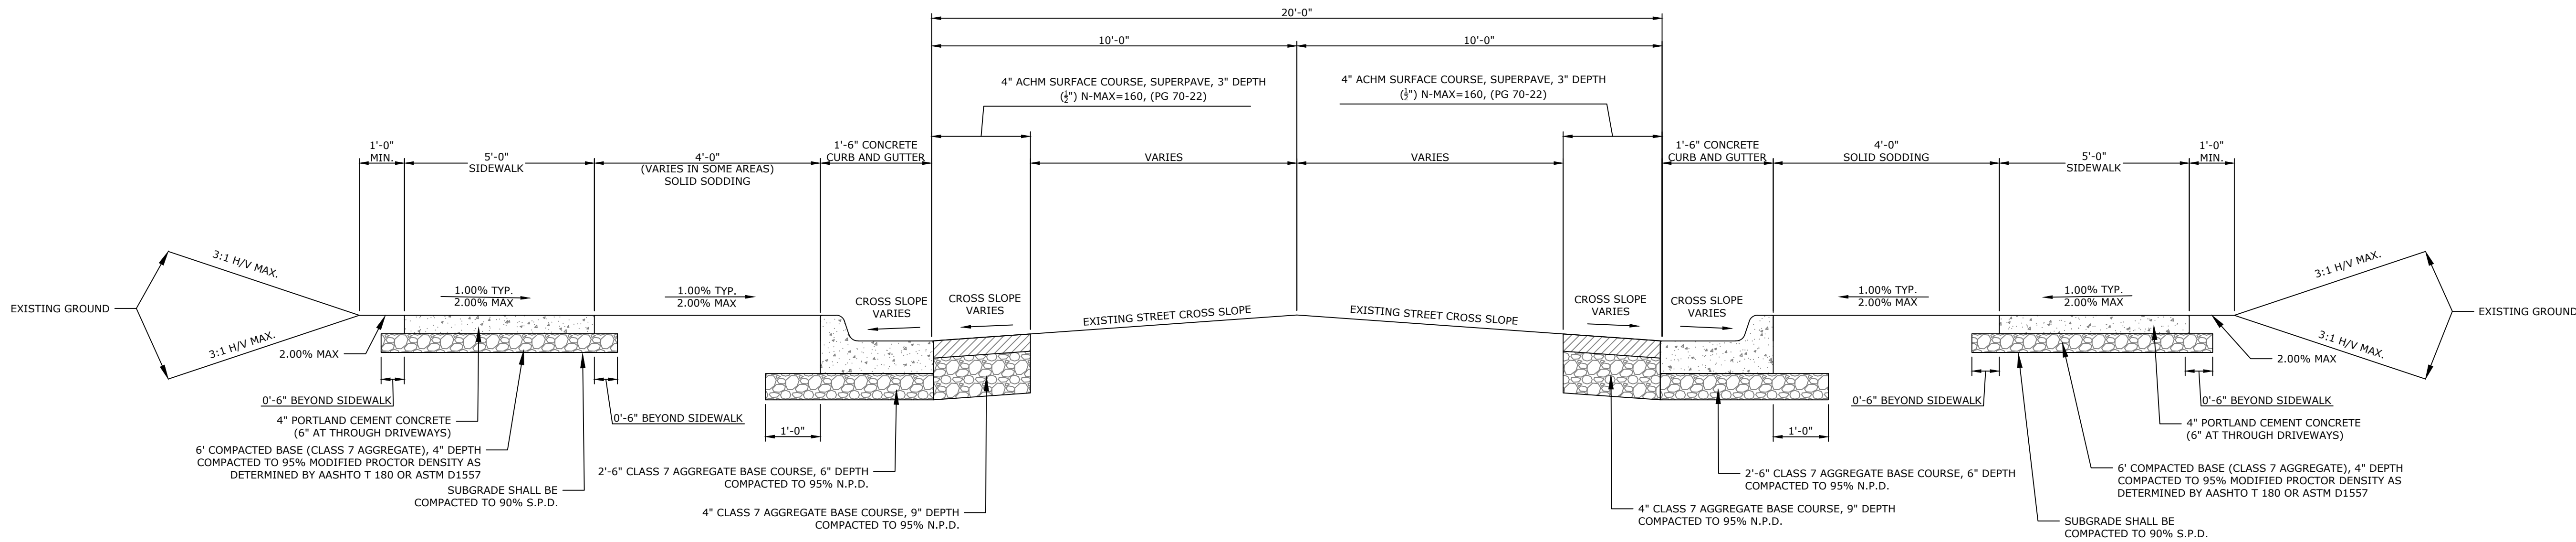

MCE
DESIGNED TO SERVE

McCLELLAND CONSULTING ENGINEERS, INC.

1580 E STEARNS ST
FAYETTEVILLE, ARKANSAS 72703
(479) 443-2377
[HTTP://WWW.MCE-US.COM](http://www.mce-us.com)

PRELIMINARY
NOT FOR
CONSTRUCTION

ORIGINAL SIGNATURE ON FILE

SE D LATERAL
DRAINAGE

BENTONVILLE, ARKANSAS



REVISIONS		DESCRIPTION
REV	DATE	

TYPICAL SECTION

DESIGNED BY:
ACP

DATE:
FEB 2022


SCALE:
N.T.S.

DRAWN BY :
ACP

REVISION:

JOB NUMBER:
21-2148

TS-1

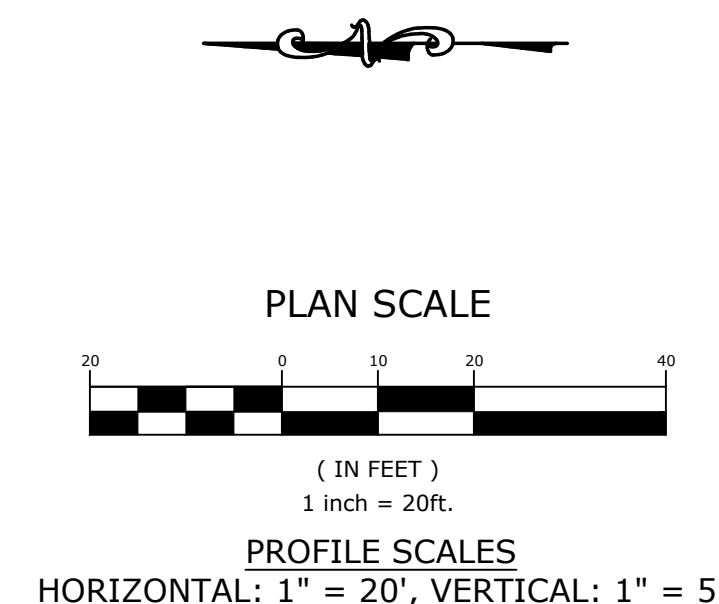

NOTE:
STORM DRAINAGE SHOWN IN PLAN VIEW IS
CONCEPTUAL. DETAILED DESIGN TO BE PROVIDED IN
60% SUBMITTAL.

MCE **McCLELLAND**
CONSULTING
ENGINEERS, INC.
DESIGNED TO SERVE

1580 E STEARNS ST
FAYETTEVILLE, ARKANSAS 72703
(479) 443-2377
[HTTP://WWW.MCE.US.COM](http://www.mce.us.com)

PRELIMINARY
NOT FOR
CONSTRUCTION

ORIGINAL SIGNATURE ON FILE

SE D LATERAL
DRAINAGE


[illegible]

PLAN AND
PROFILE STA.
100+00 TO
STA. 102+00

DESIGNED BY: ACP	DRAWN BY : ACP
DATE: FEB 2022	REVISION:
SCALE: 1" = 20'	JOB NUMBER: 21-2148

PP-1

Y:\2021\21-2148 - SE D Lateral, Drainage\Design Drawings\Civil\21-2148-DESIGN.dwg, PRINTED ON: February 4, 2022 @ 12:16 PM

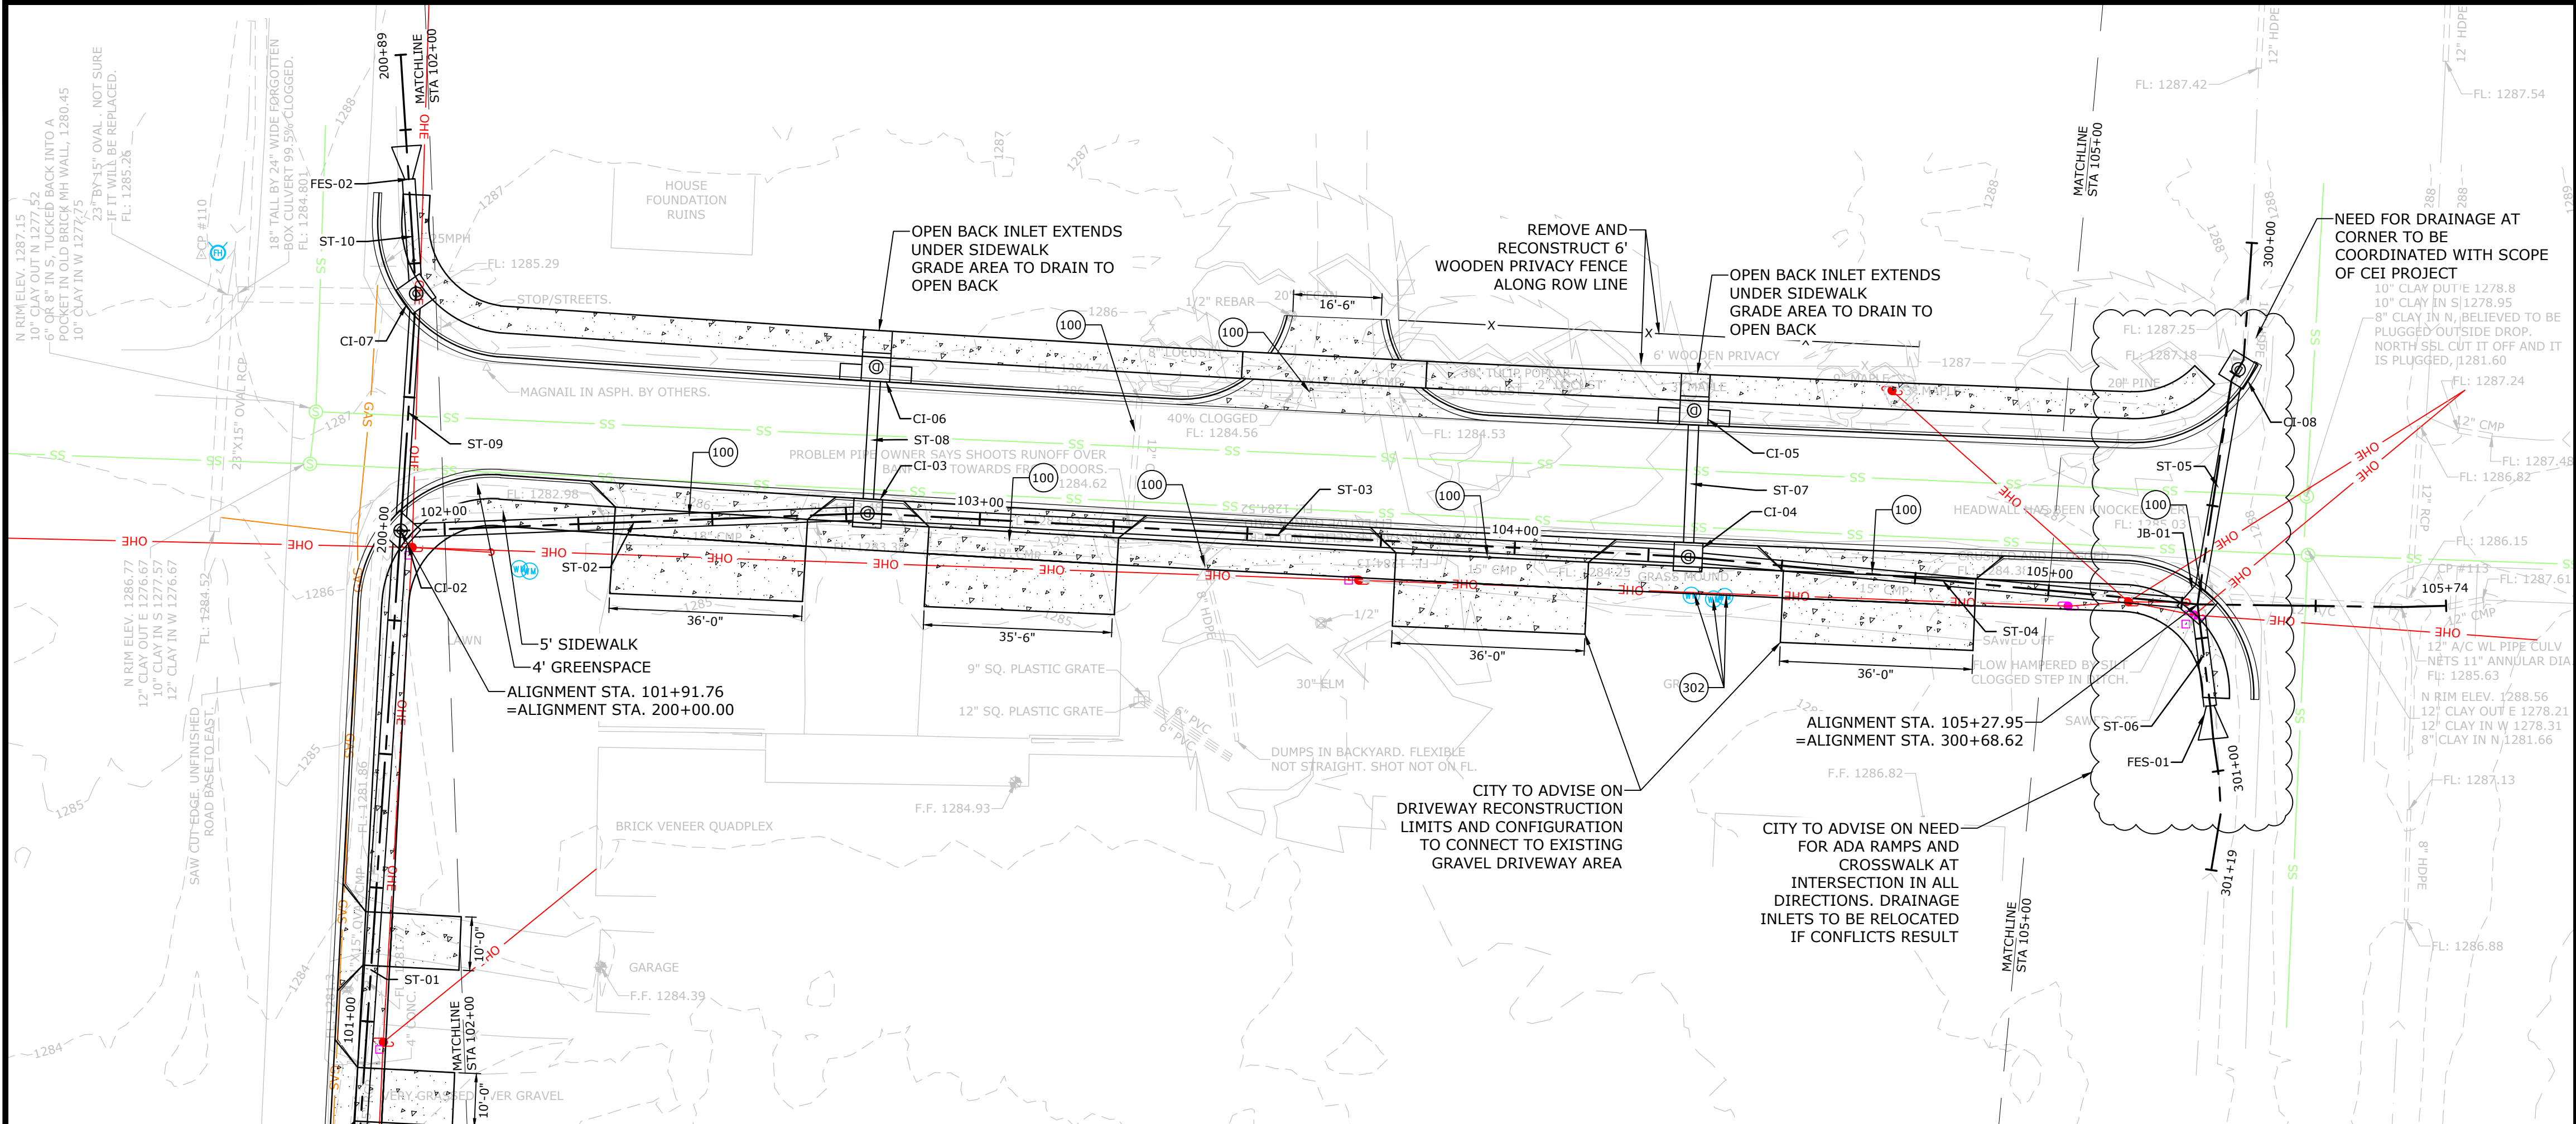

PROPOSED LEGEND

- CURB AND GUTTER
- CONCRETE PAVEMENT AND SIDEWALK
- STORM DRAIN STRUCTURE
- FLARED END SECTION
- PROPOSED STORM DRAIN
- PROPOSED CENTERLINE



EXISTING LEGEND

- SANITARY SEWER LINE
- WATER LINE
- GAS LINE
- UNDERGROUND TELEPHONE
- UNDERGROUND ELECTRIC
- UNDERGROUND TELEVISION
- UNDERGROUND FIBER
- OVERHEAD ELECTRIC
- STORM DRAINAGE PIPE
- FENCE
- ROAD CENTERLINE
- DITCH FLOWLINE
- EASEMENT LINE
- GRAVEL LINE
- FIRE HYDRANT
- WATER METER
- WATER VALVE
- WATER FAUCET
- SANITARY SEWER MH
- CLEAN-OUT
- DRAINAGE MH
- POWER POLE
- GUY WIRE w/ ANCHOR
- GAS RISER
- GAS RISER
- STREET LIGHT POLE
- TELEPHONE PEDESTAL
- CABLE TV PEDESTAL
- SIGN (AS NOTED)
- POST (AS NOTED)
- BENCHMARK
- FOUND IRON PIN (AS NOTED)
- CONTROL POINT
- RR SPIKE
- BUSH
- TREE


PLAN KEYNOTES

- 100 EXISTING TO BE REMOVED AND / OR DEMOLISHED
- 106 LIMITS OF DISTURBANCE
- 151 UTILITY FACILITY TO BE RELOCATED
- 302 ADJUST ELEVATION TO MATCH FINISHED GRADE

NOTE:
STORM DRAINAGE SHOWN IN PLAN VIEW IS
CONCEPTUAL. DETAILED DESIGN TO BE PROVIDED IN
60% SUBMITTAL.

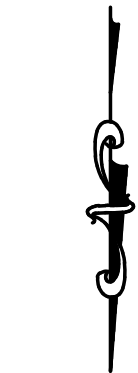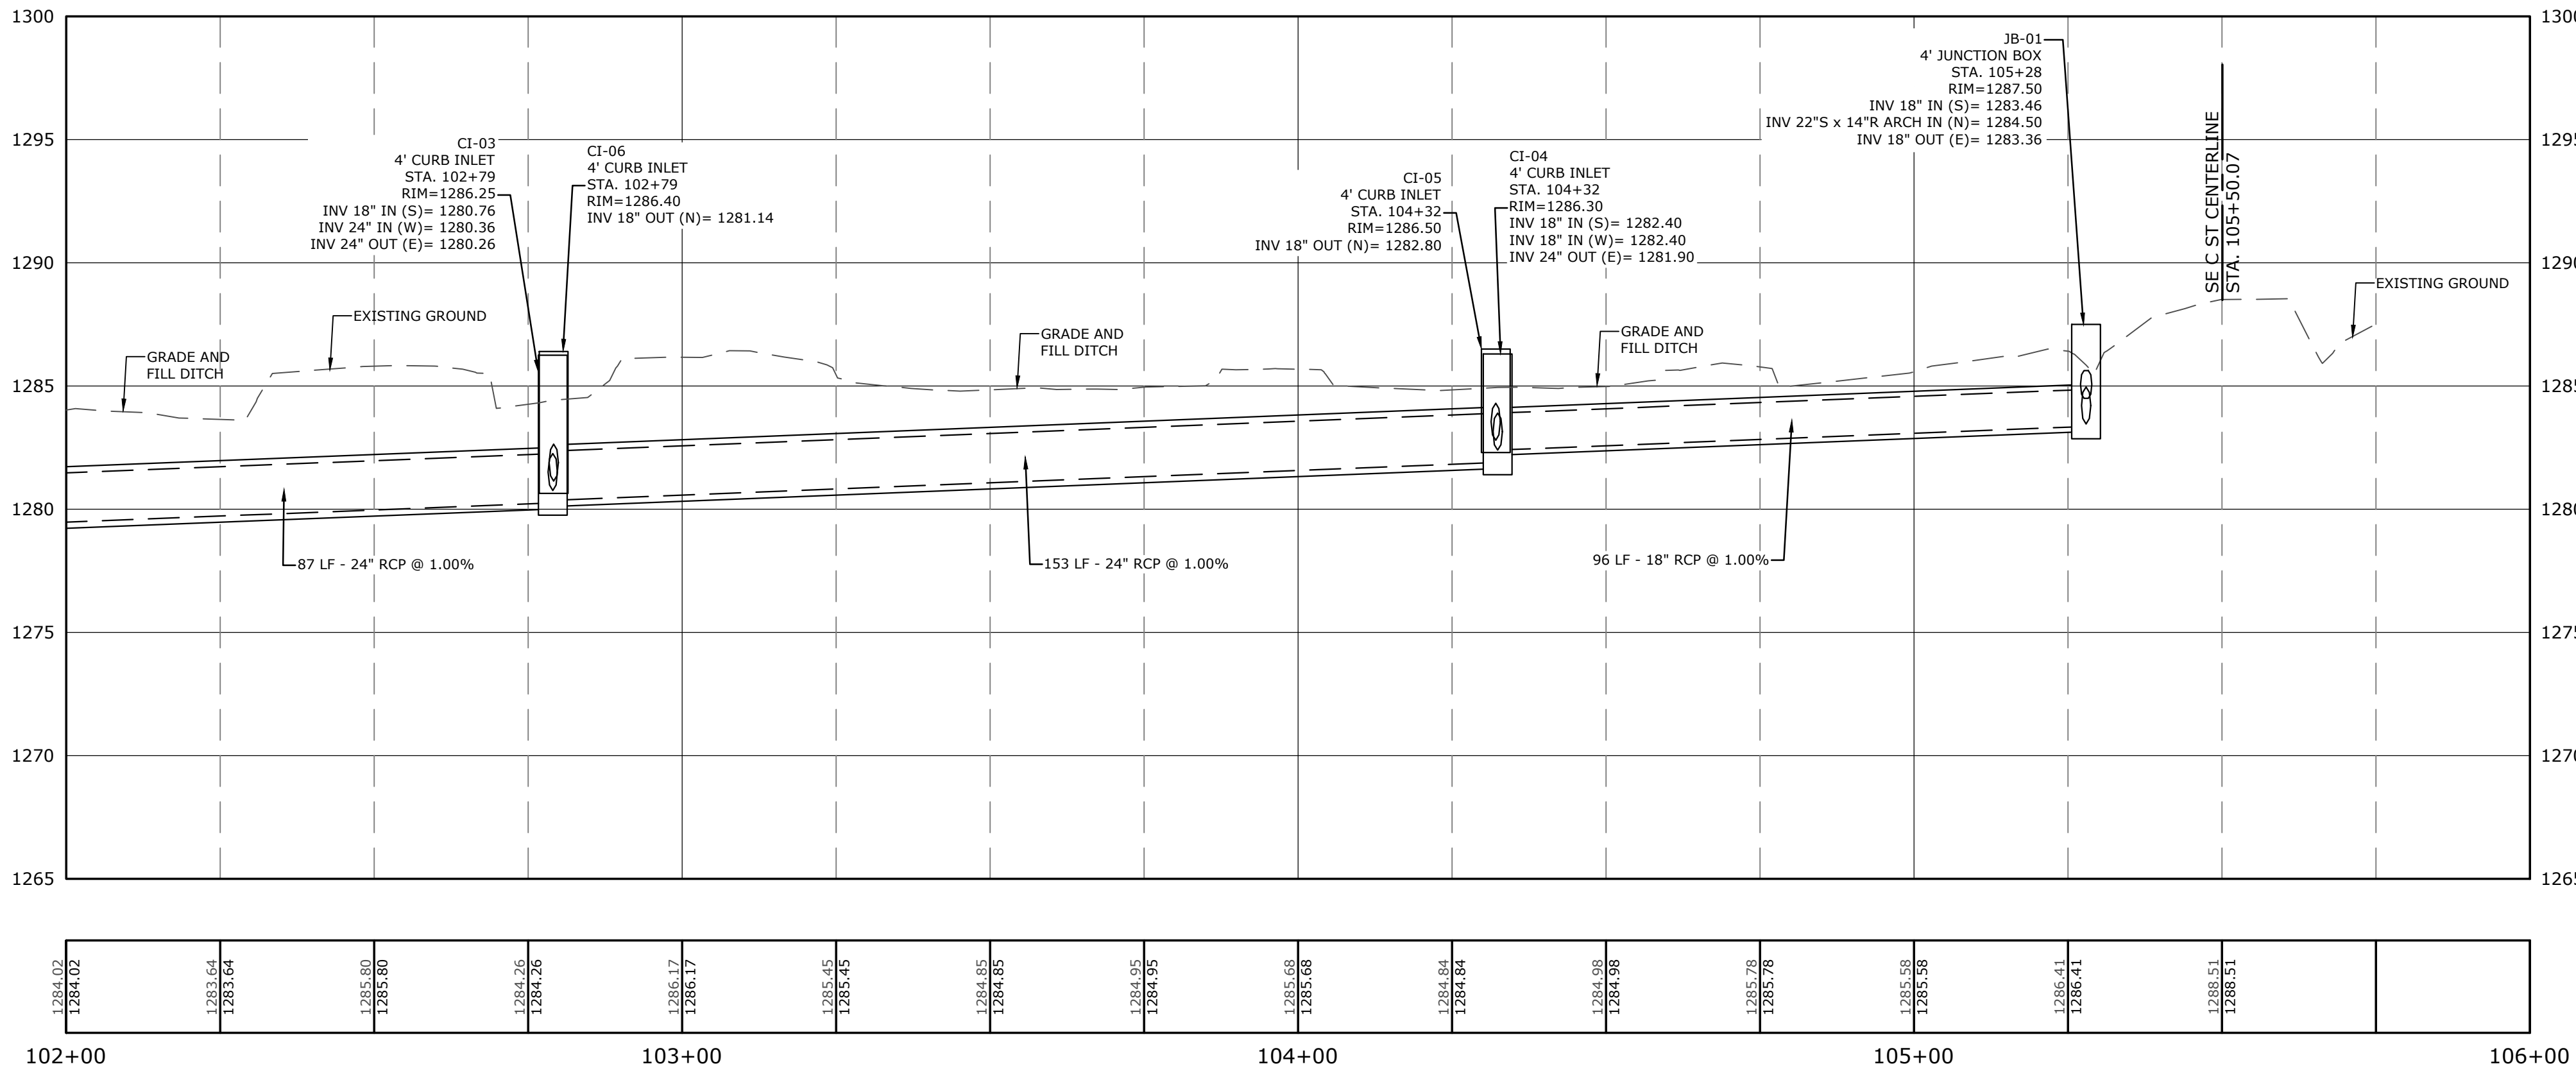

PLAN SCALE

 

(IN FEET)
1 inch = 20ft.

PROFILE SCALES

HORIZONTAL: 1" = 20', VERTICAL: 1" = 5'

PRELIMINARY
NOT FOR
CONSTRUCTION

ORIGINAL SIGNATURE ON FILE

SE D LATERAL
DRAINAGE
BENTONVILLE, ARKANSAS





REVISIONS		DESCRIPTION
REV	DATE	

PLAN AND
PROFILE STA.
102+00 TO
STA. 106+00

DESIGNED BY: ACP	DRAWN BY : ACP
DATE: FEB 2022	REVISION:
SCALE: 1" = 20'	JOB NUMBER: 21-2148

PP-2

Y:\2021\21-2148 - SE D Lateral, Drainage\Design Drawings\Civil\21-2148-DESIGN.dwg, PRINTED ON: February 4, 2022 @ 12:18 PM

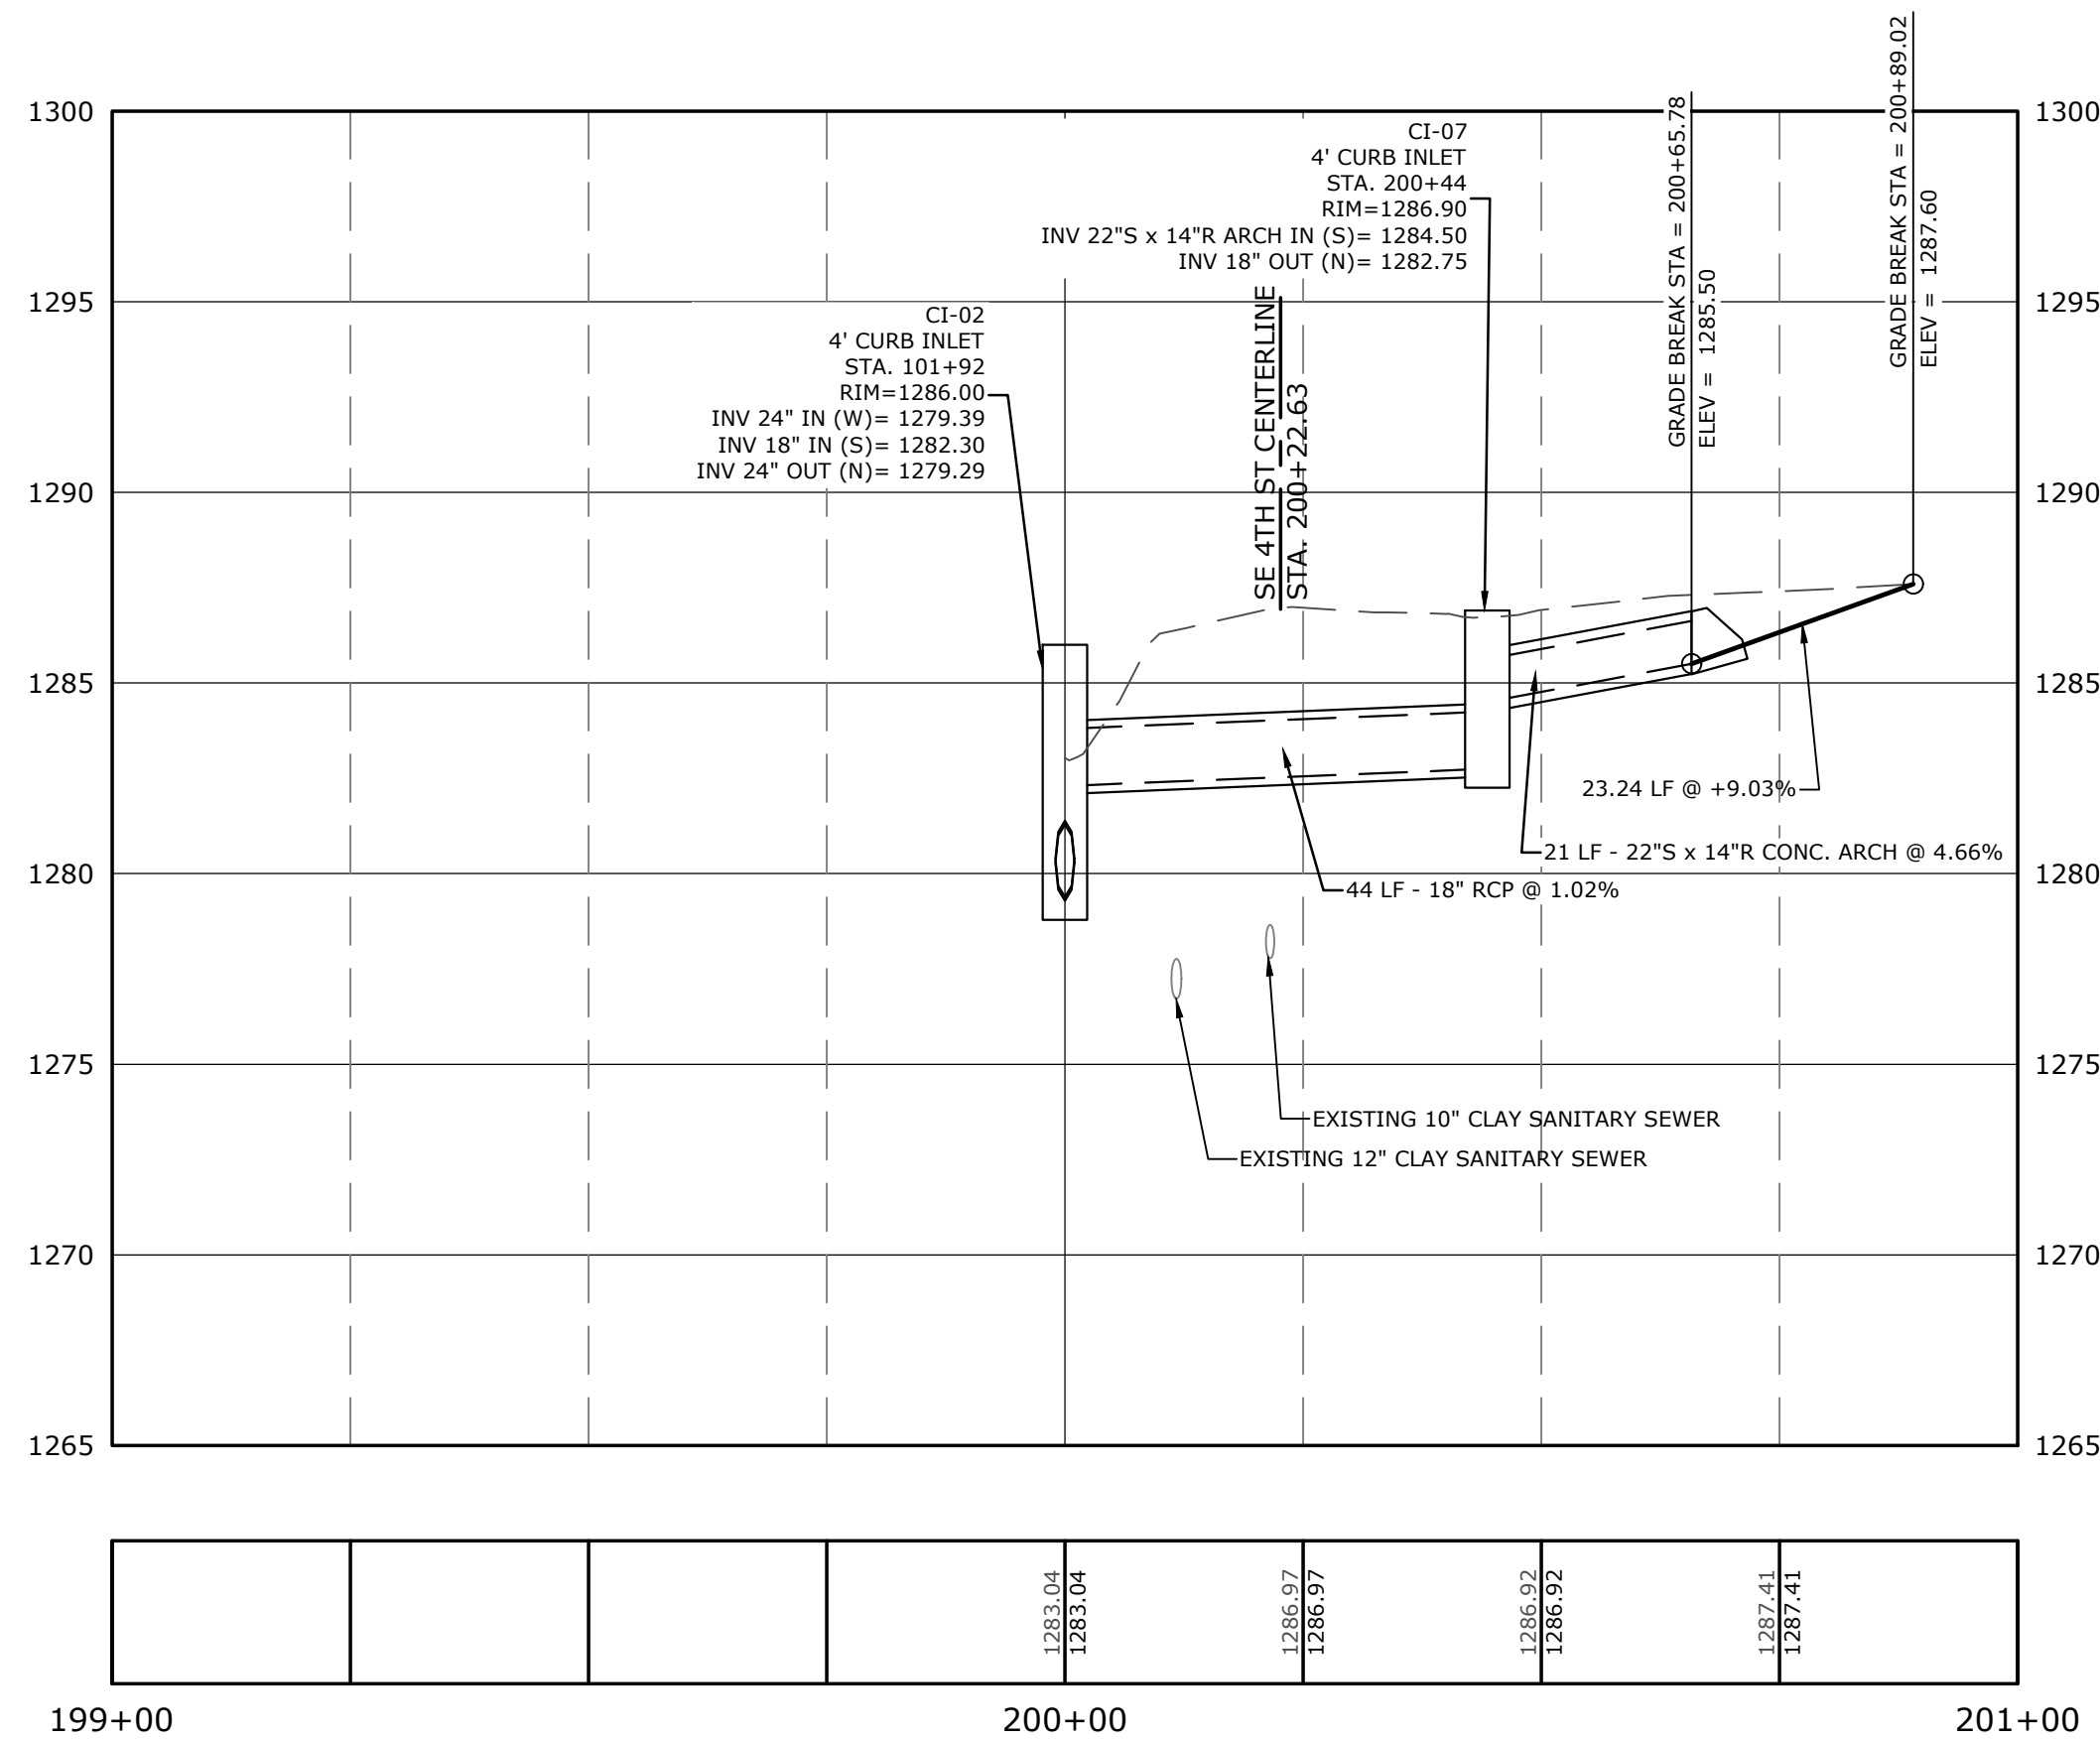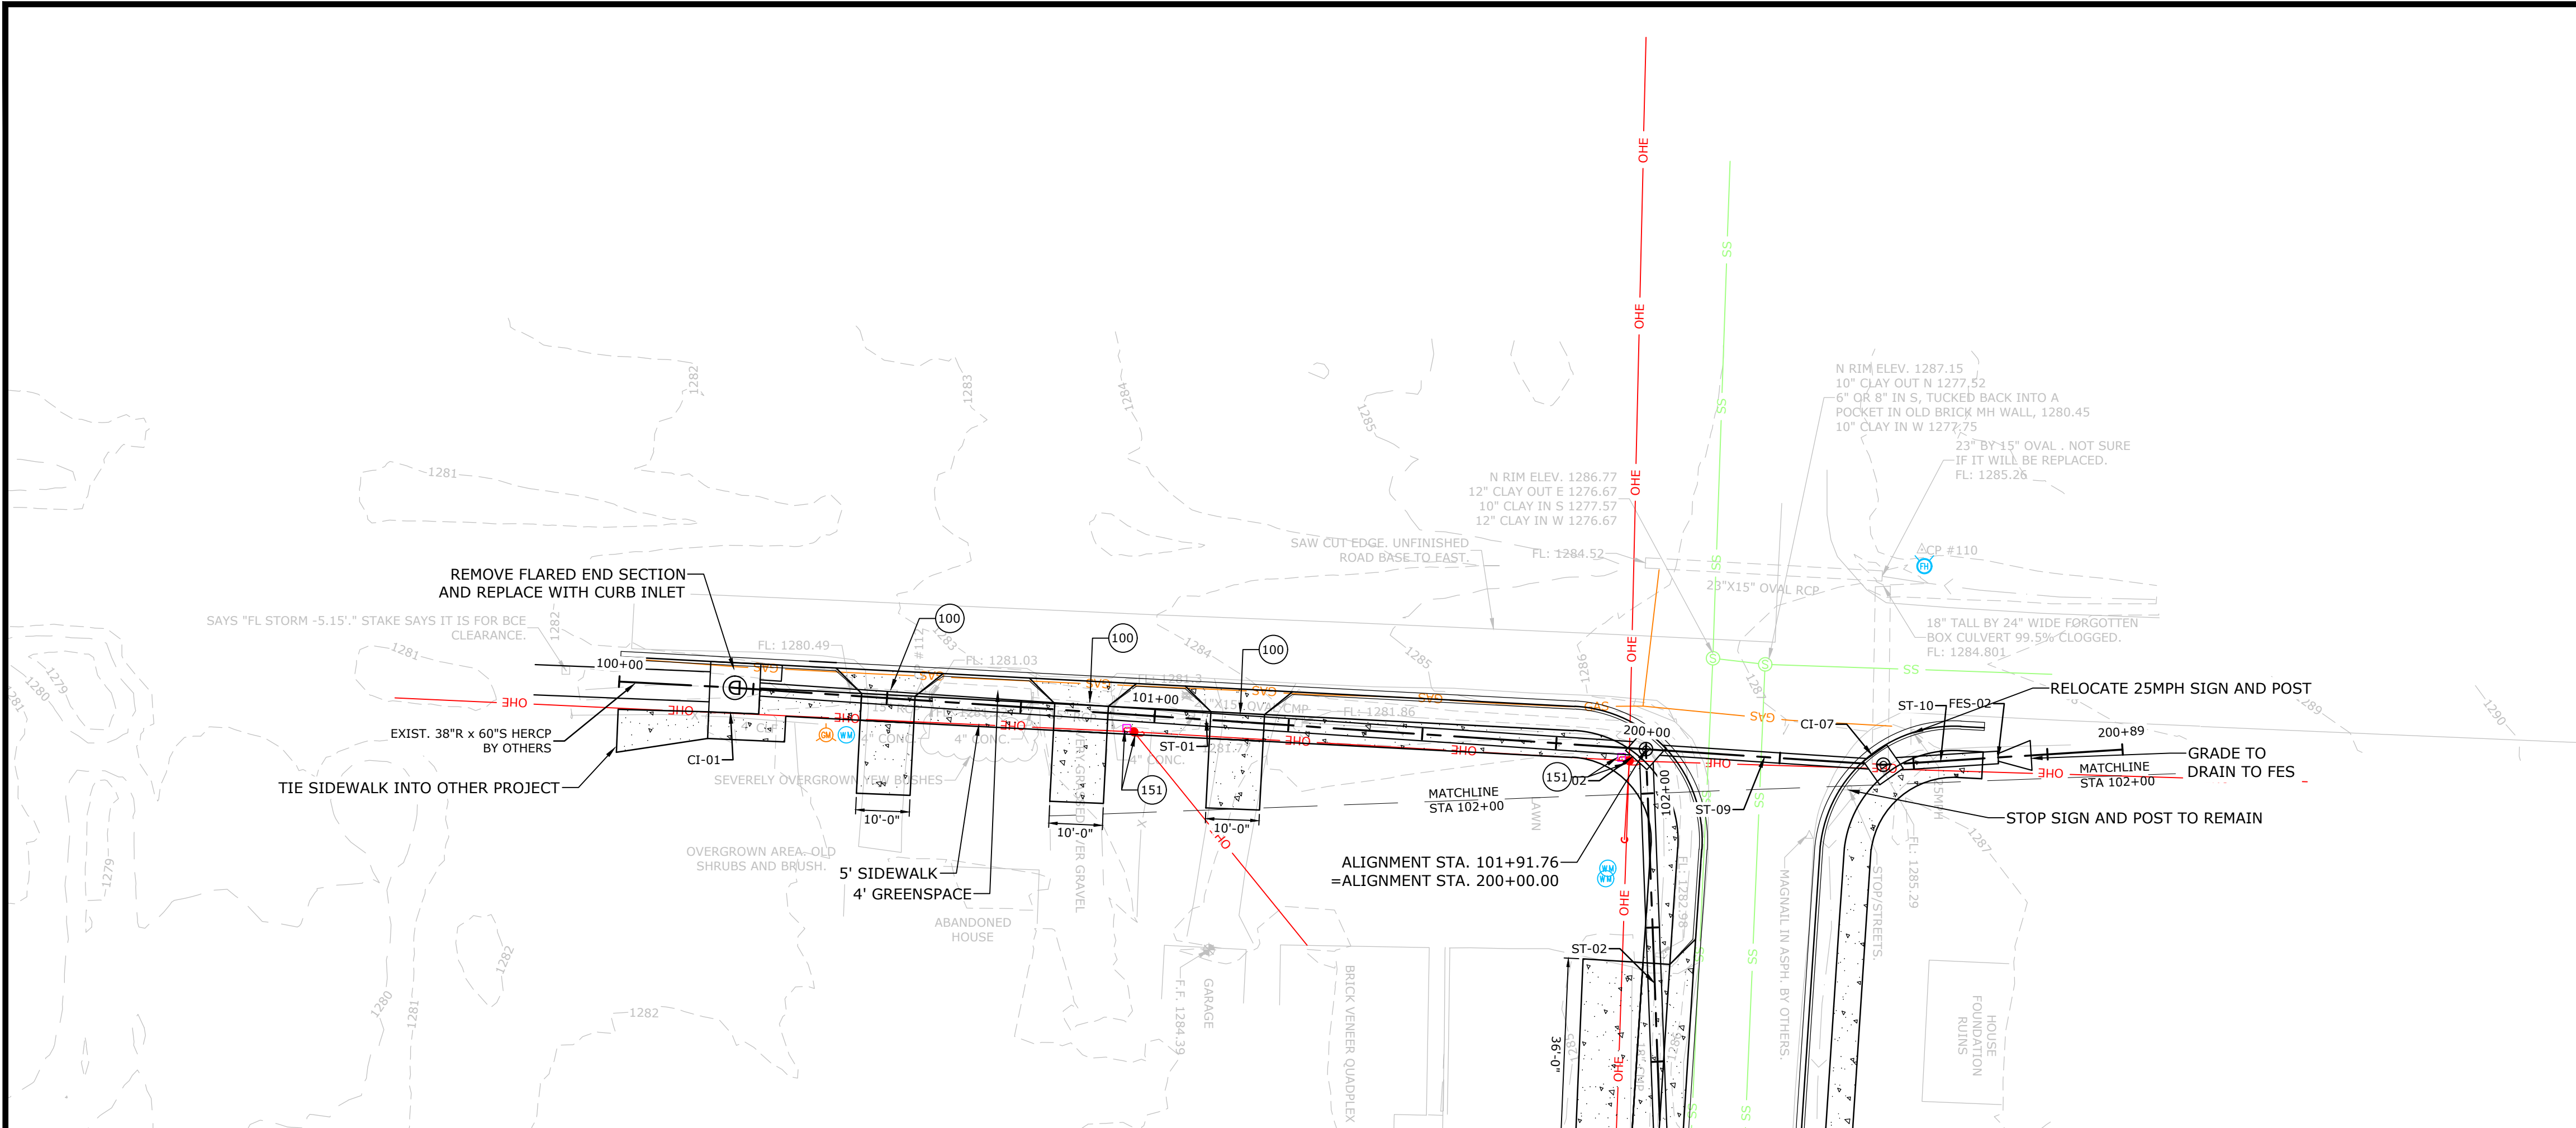

PROPOSED LEGEND

- CURB AND GUTTER
- CONCRETE PAVEMENT AND SIDEWALK
- STORM DRAIN STRUCTURE
- FLARED END SECTION
- PROPOSED STORM DRAIN
- PROPOSED CENTERLINE


EXISTING LEGEND

- SANITARY SEWER LINE
- WATER LINE
- GAS LINE
- UNDERGROUND TELEPHONE
- UNDERGROUND ELECTRIC
- UNDERGROUND TELEVISION
- UNDERGROUND FIBER
- OVERHEAD ELECTRIC
- STORM DRAINAGE PIPE
- FENCE
- ROAD CENTERLINE
- DITCH FLOWLINE
- EASEMENT LINE
- GRAVEL LINE
- FIRE HYDRANT
- WATER METER
- WATER VALVE
- WATER FAUCET
- SANITARY SEWER MH
- CLEAN-OUT
- DRAINAGE MH
- POWER POLE
- GUY WIRE w/ ANCHOR
- GAS METER
- GAS RISER
- STREET LIGHT POLE
- TELEPHONE PEDESTAL
- CABLE TV PEDESTAL
- SIGN (AS NOTED)
- POST (AS NOTED)
- BENCHMARK
- FOUND IRON PIN (AS NOTED)
- CONTROL POINT
- RR SPIKE
- BUSH
- TREE

PLAN KEYNOTES

- 100 EXISTING TO BE REMOVED AND / OR DEMOLISHED
- 106 LIMITS OF DISTURBANCE
- 151 UTILITY FACILITY TO BE RELOCATED
- 302 ADJUST ELEVATION TO MATCH FINISHED GRADE

NOTE:
STORM DRAINAGE SHOWN IN PLAN VIEW IS
CONCEPTUAL. DETAILED DESIGN TO BE PROVIDED IN
60% SUBMITTAL.

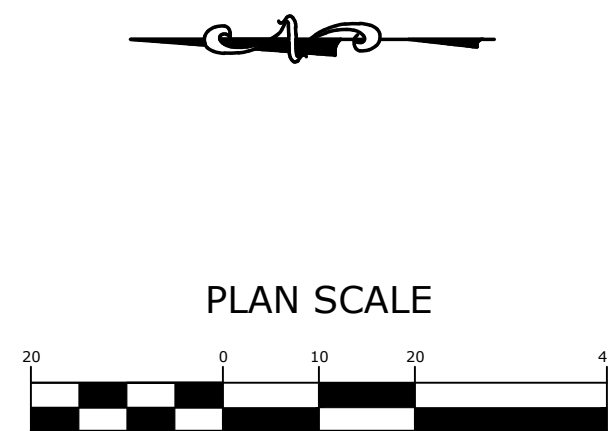

PROFILE SCALES
HORIZONTAL: 1" = 20', VERTICAL: 1" = 5'

PRELIMINARY
NOT FOR
CONSTRUCTION

ORIGINAL SIGNATURE ON FILE

SE D LATERAL
DRAINAGE
BENTONVILLE, ARKANSAS




REVISIONS	
REV	DESCRIPTION

PLAN AND
PROFILE STA.
200+00 TO
STA. 201+00

DESIGNED BY: ACP	DRAWN BY : ACP
DATE: FEB 2022	REVISION:
SCALE: 1" = 20'	JOB NUMBER: 21-2148

PP-3

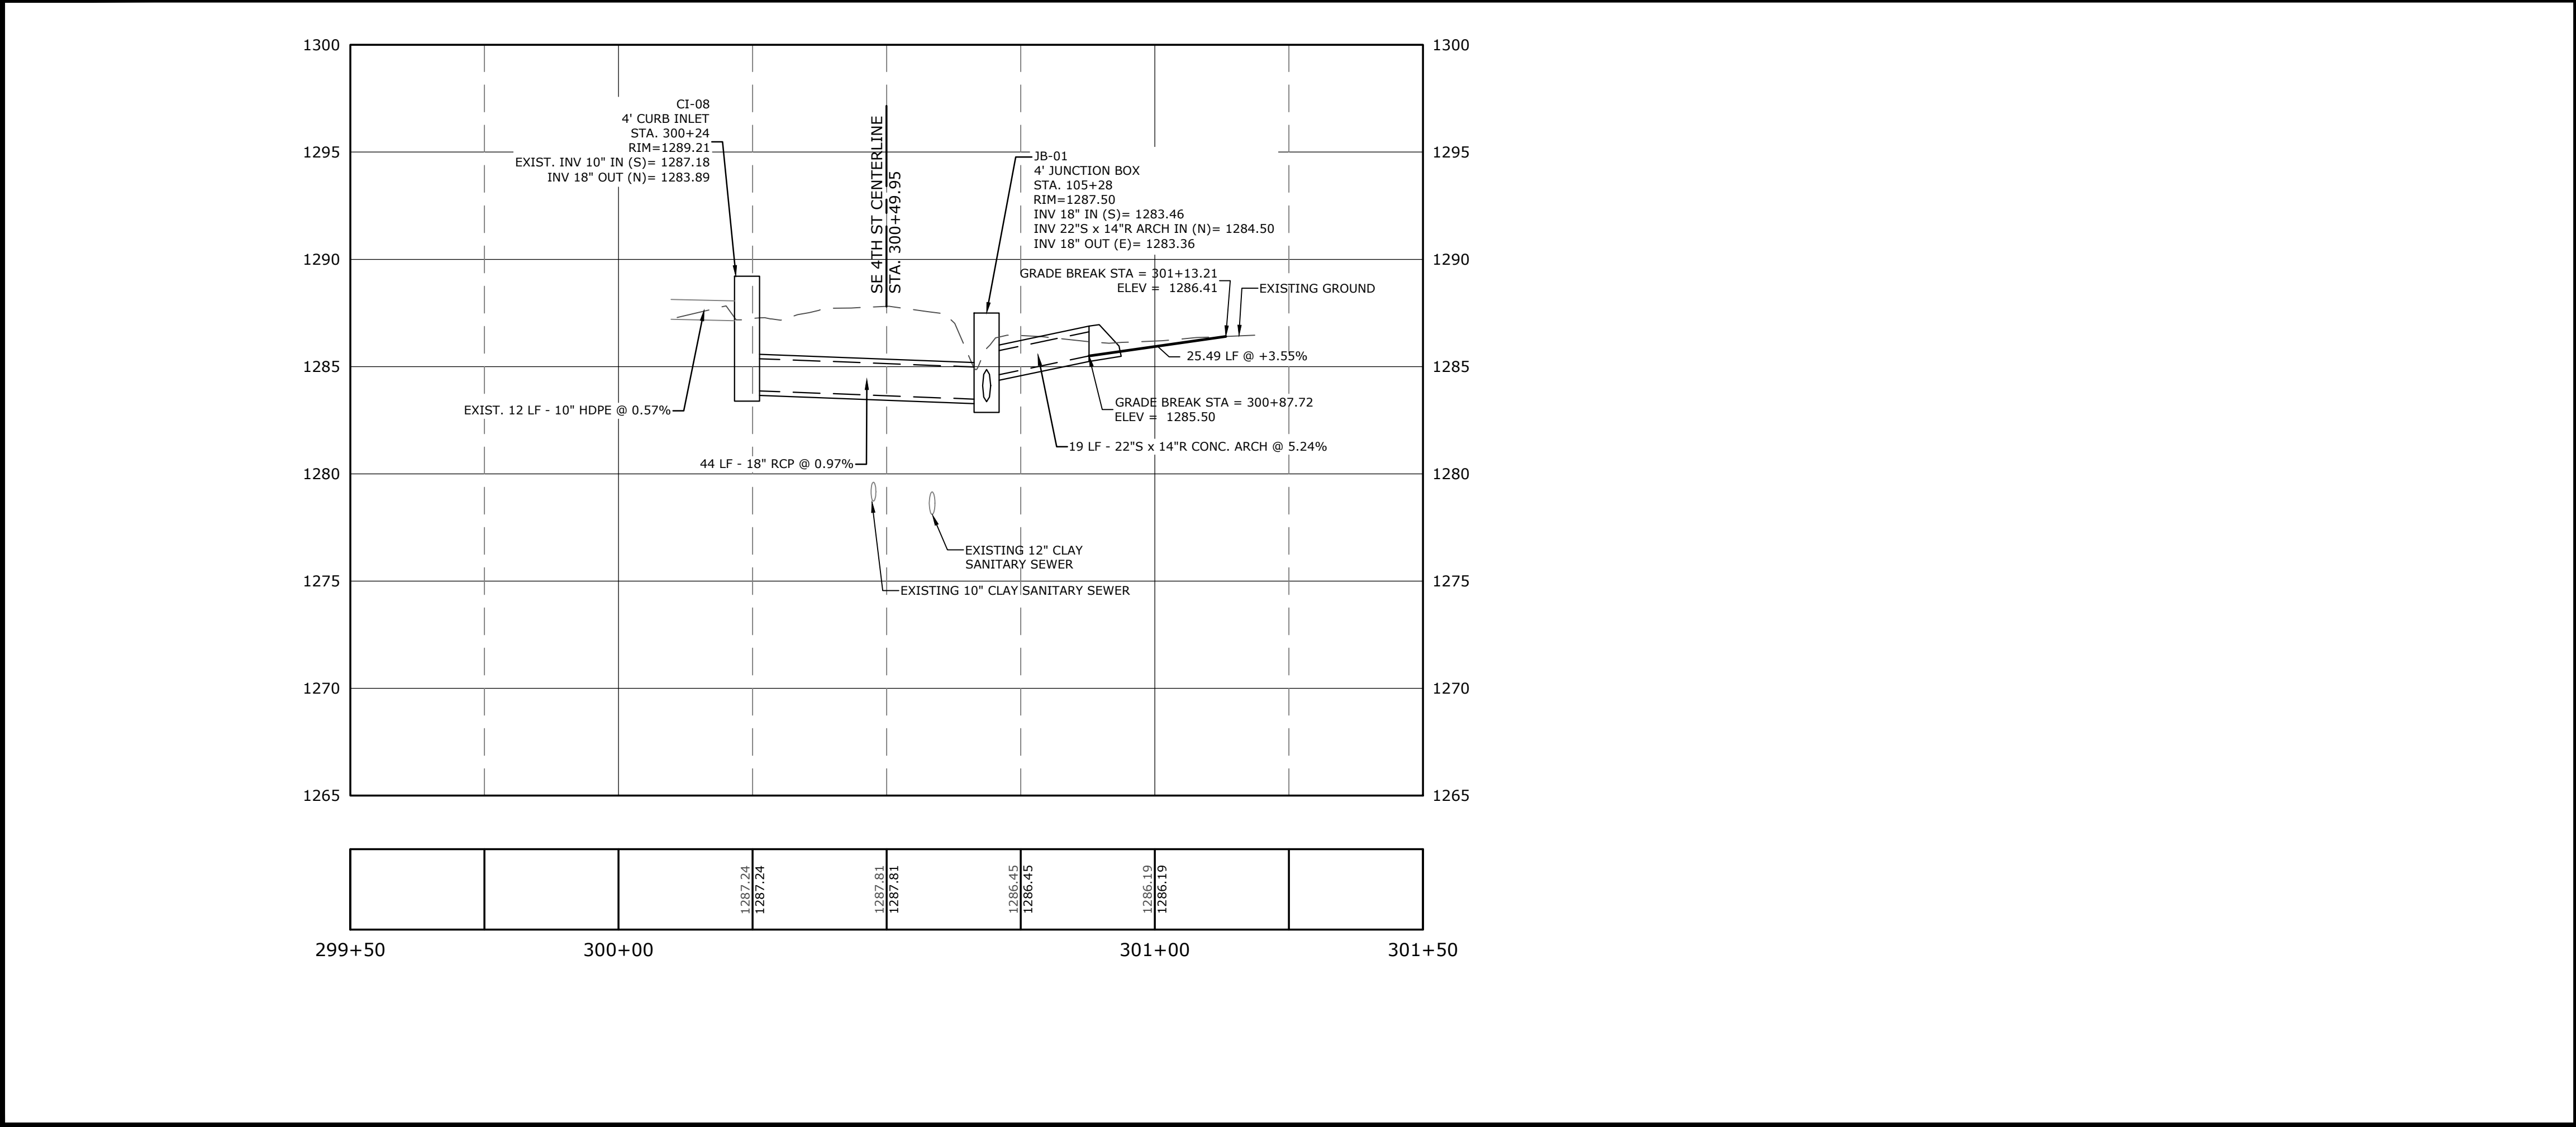

PLAN SCALE

20 0 10 20 40



(IN FEET)
1 inch = 20ft.

PROFILE SCALES

HORIZONTAL: 1" = 20', VERTICAL: 1"

 MCE McCLELLAND CONSULTING ENGINEERS, INC. DESIGNED TO SERVE		1580 E STEARNS ST FAYETTEVILLE, ARKANSAS 72703 (479) 443-2377 HTTP://WWW.MCE.US.COM	
PRELIMINARY NOT FOR CONSTRUCTION			
ORIGINAL SIGNATURE ON FILE			
SE D LATERAL DRAINAGE		BENTONVILLE, ARKANSAS	
 THE CITY OF BENTONVILLE			
 Know what's below. Call before you dig.			
REVISIONS			
REV	DATE	DESCRIPTION	
PLAN AND PROFILE STA. 300+00 TO STA. 301+50			
DESIGNED BY: ACP		DRAWN BY : ACP	
DATE: FEB 2022		REVISION:	
SCALE: 1" = 20'		JOB NUMBER: 21-2148	
PP-4			

Y:\2021\21-2148 - SE D Lateral, Drainage\Design Drawings\Civil\21-2148-DESIGN.dwg, PRINTED ON: January 31, 2022 @ 4:41 PM

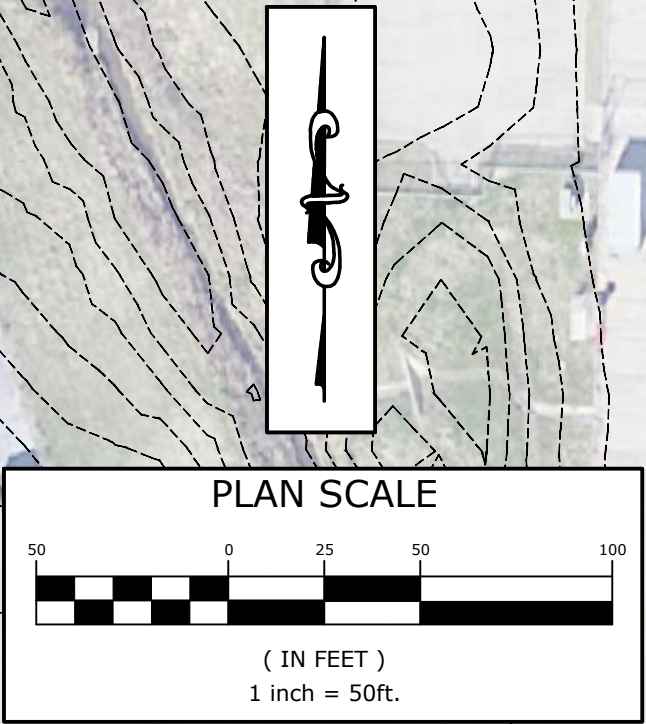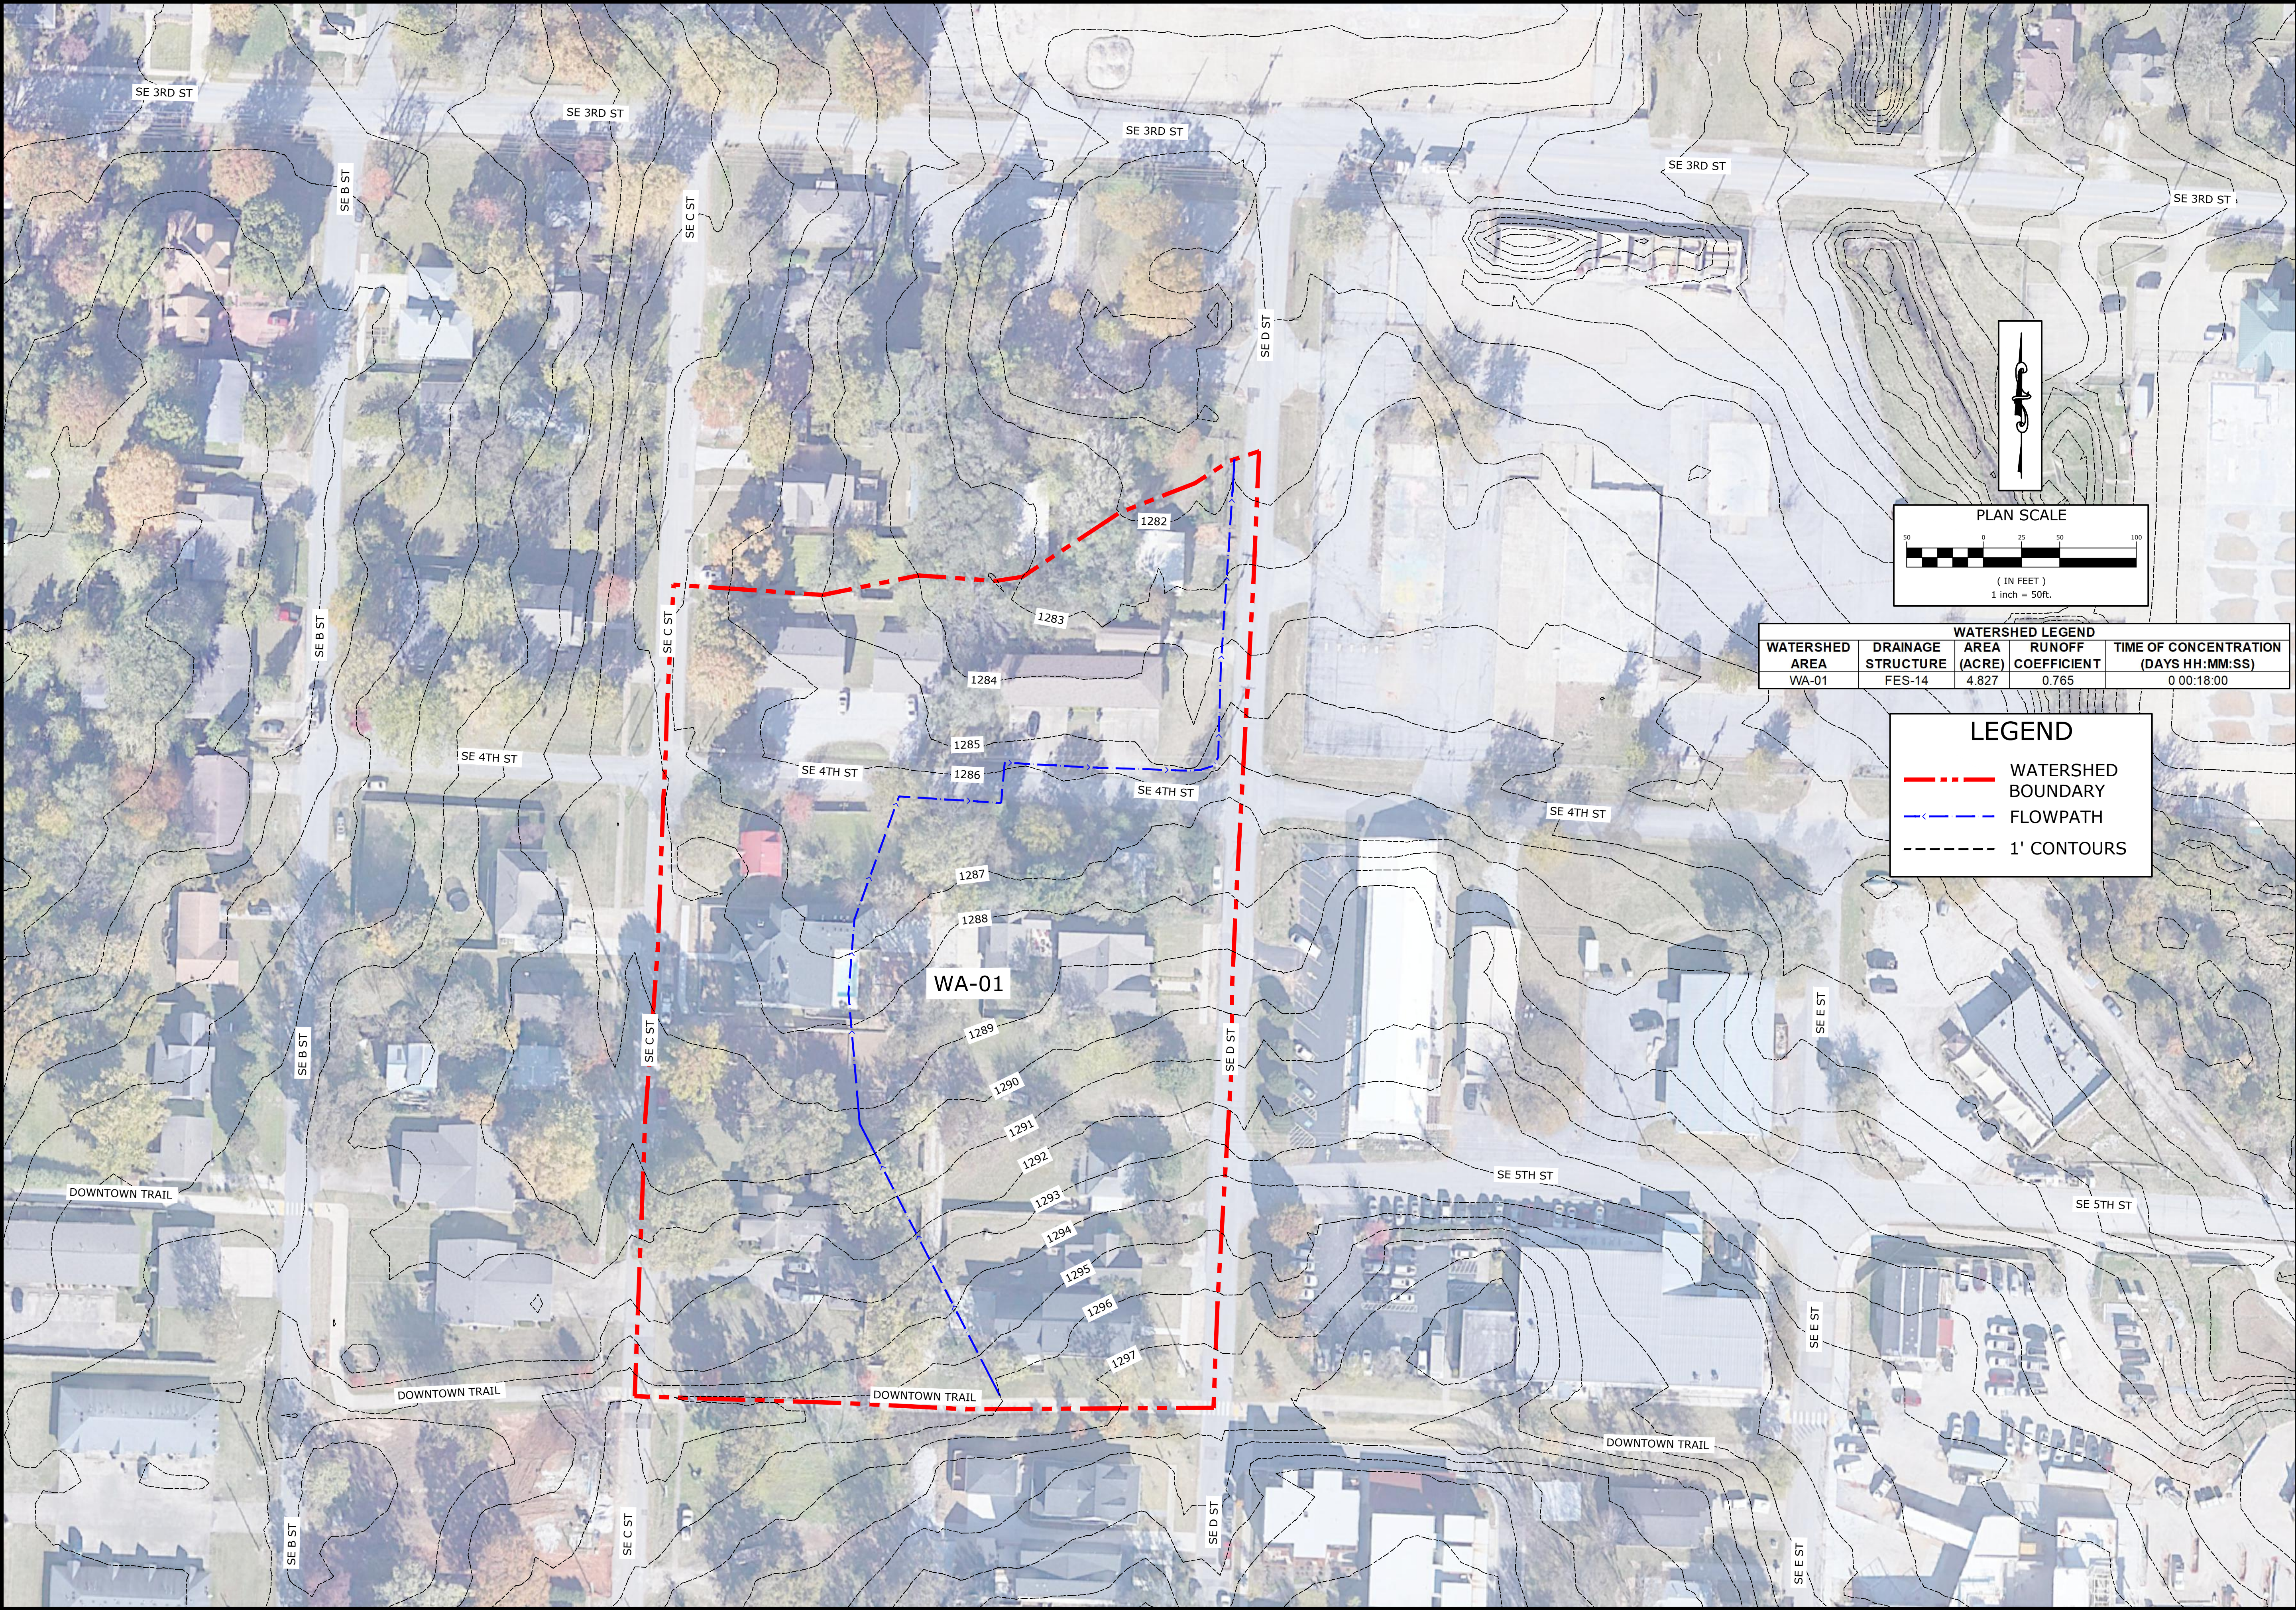

WATERSHED LEGEND				
WATERSHED AREA	DRAINAGE STRUCTURE	AREA (ACRE)	RUNOFF COEFFICIENT	TIME OF CONCENTRATION (DAYS HH:MM:SS)
WA-01	FES-14	4.827	0.765	0 00:18:00

LEGEND

WATERSHED BOUNDARY

FLOWPATH

1' CONTOURS

MCE

McCLELLAND

CONSULTING

ENGINEERS, INC.

DESIGNED TO SERVE

NOT FOR CONSTRUCTION

1580 E STEARNS ST

FAYETTEVILLE, ARKANSAS 72703

(479) 443-2377

HTTP://WWW.MCE.US.COM

PRELIMINARY

NOT FOR CONSTRUCTION

ORIGINAL SIGNATURE ON FILE

SE D LATERAL DRAINAGE

BENTONVILLE, ARKANSAS

THE CITY OF

B

BENTONVILLE

811

Know what's below.

Call before you dig.

REVISIONS		DESCRIPTION
REV	DATE	

EXISTING WATERSHED MAP

DESIGNED BY: ACP

DATE: FEB 2022

SCALE: 1" = 50'

DRAWN BY: ACP

REVISION:

JOB NUMBER: 21-2148

WS-1

